

NOTES

- 3/8" EPOXY TERRAZZO PORED FLOOR PREP. TO RECEIVE BAMBOOO INSETS
- 3/8" PRECAST EPOXY TERRAZZO BAMBOO DESIGN INSETS (3MOLDS FOR GREEN INSETS AND 3 MOLDS FOR BROWN INSETS)
- 3/8" PRECAST EPOXY TERRAZZO BAMBOO DESIGN INSETS (3MOLDS FOR GREEN INSETS, 3 MOLDS FOR BROWN INSETS)
- TERRAZZO SAND 6" PRECAST BASE

BATHROOM WALL TILES: SEE SPECIFICATIONS (BOOK) FOR DETAILS . SEE RELATED DETAILS @ SHEET 2/ I.4.01. IT IS THE GENERAL CONTRACTOR'S RESPONSIBILITY TO PROVIDE THE WALL TILE IN ITS ENTIRETY, INCLUDING: DEMOLITION AND PATCHING OF EXISTING WALLS, REQUIRED SUBSTRATE PREPARATION, MATERIALS SUPPLY AND INSTALLATION.


BATH PARTITIONS - ACCURATE PARTITIONS CORP. OR APPROVED EQUAL POWDER COATED STEEL (ADOBE #917), NEW HARDWARE ASSEMBLY TO MATCH EXISTING, IE FLOOR ANCHORED/ OVERHEAD BRACED

SOLID SURFACE FOR BATHROOM COUNTERS - SOLID SURFACE - CORIAN, COLOR: TARRAGON OR APPROVED EQUAL
PLUMBING FIXTURES = AMERICAN STANDARD (WHITE) SEE PLUMBING SCHEDULE


PLUMBING HARDWARE = POLISHED CHROME SEE PLUMBING SCHEDULE

PAINT ABOVE THE WALL TILES IN BATHROOMS LATEX ACRYLIC, TBD


TERRAZZO DESIGN TO BE DRAWN IN THE FIELD AFTER PRELIMINARY FLOOR DEMO
LINEAR FOOTAGE OF BAMBOO FEATURE REFLECTED IN PLANS, NOT TO EXCEED 140 LINEAR FEET FOR THE PROJECT.

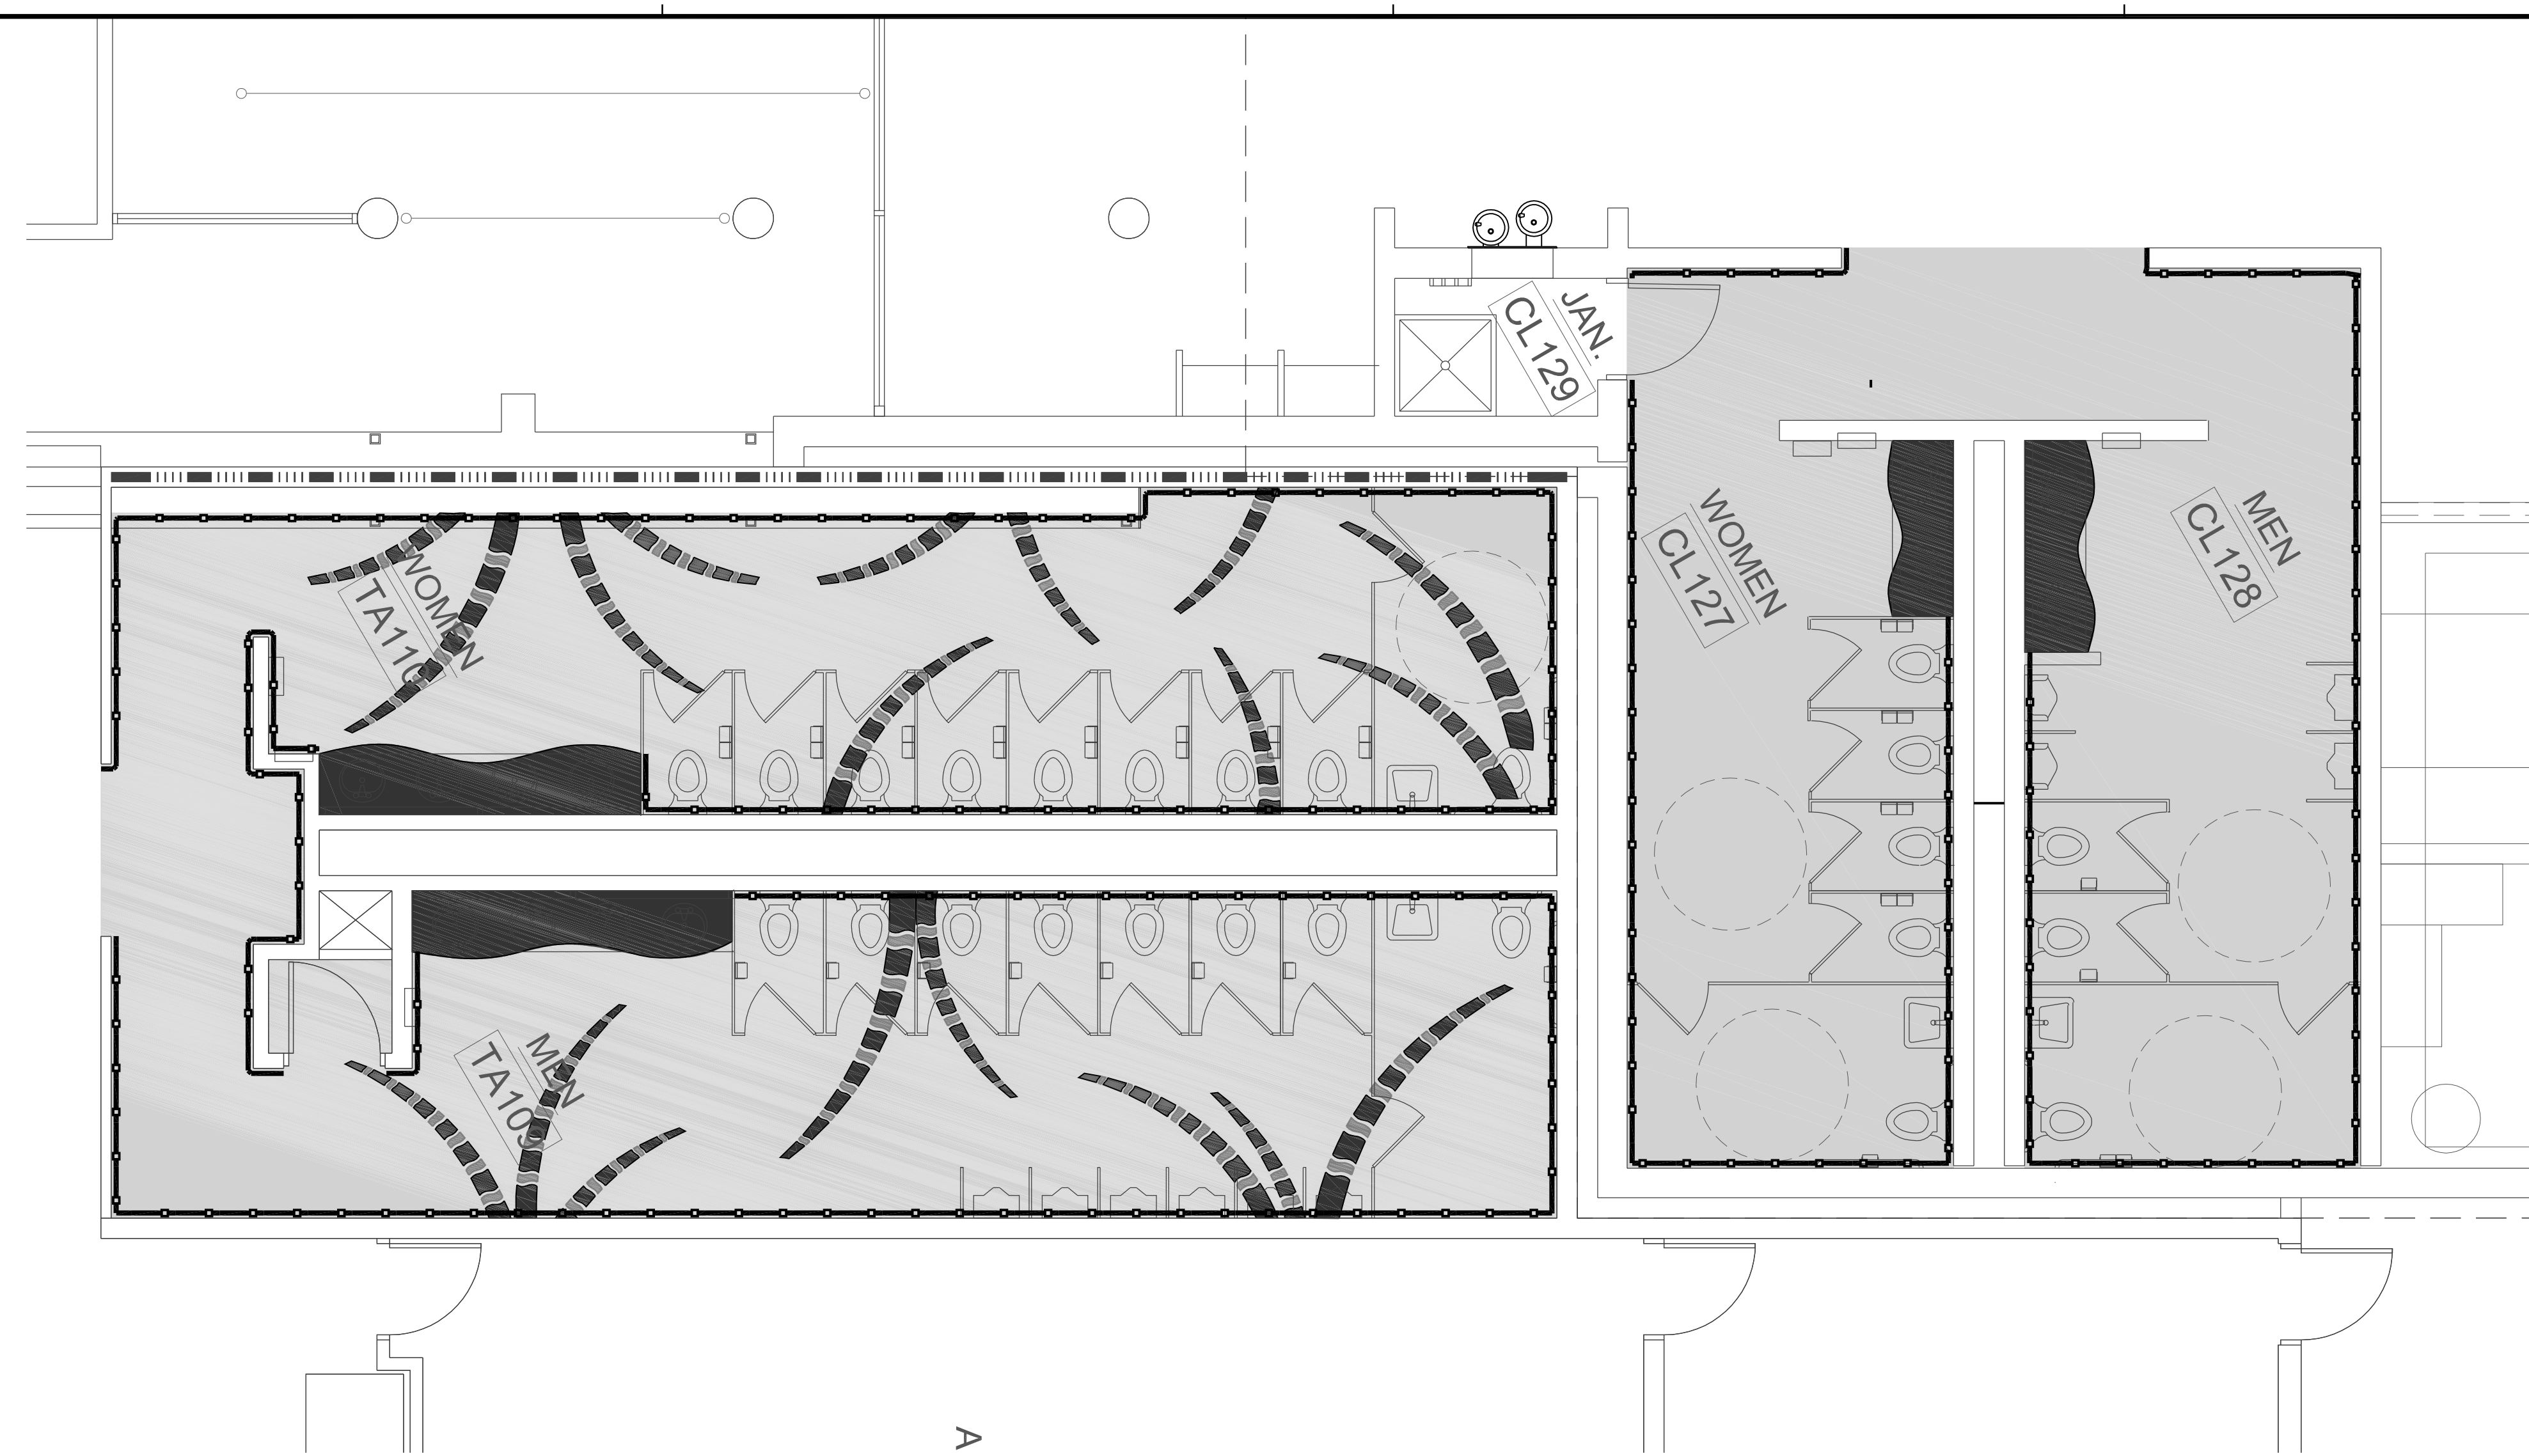


1 FLOOR PLAN
BATHROOM FLOORING
SCALE: 1/4" = 1'-0"

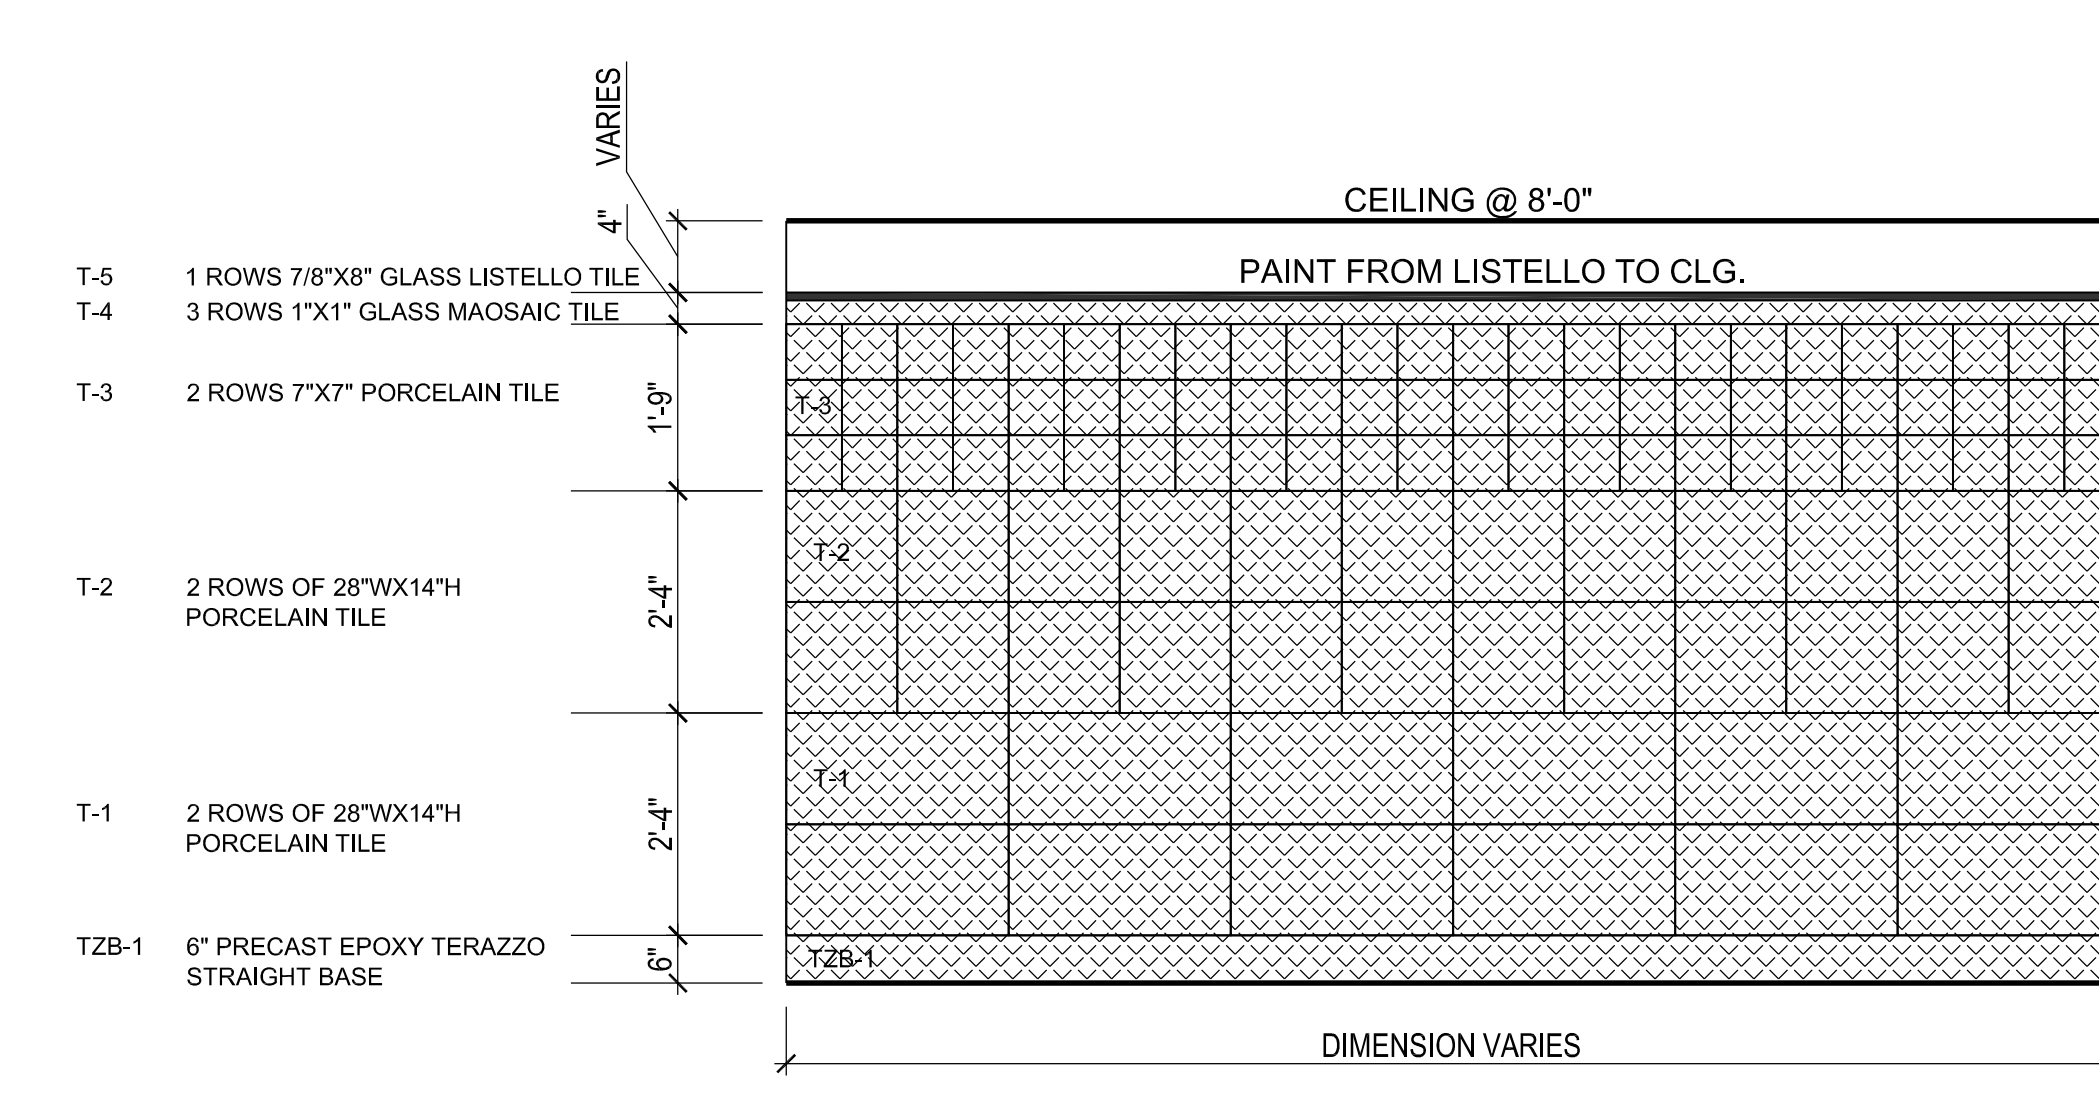


2 ELEVATION
BATHROOM WALLS - TYPICAL DETAIL
SCALE: 1/2" = 1'-0"

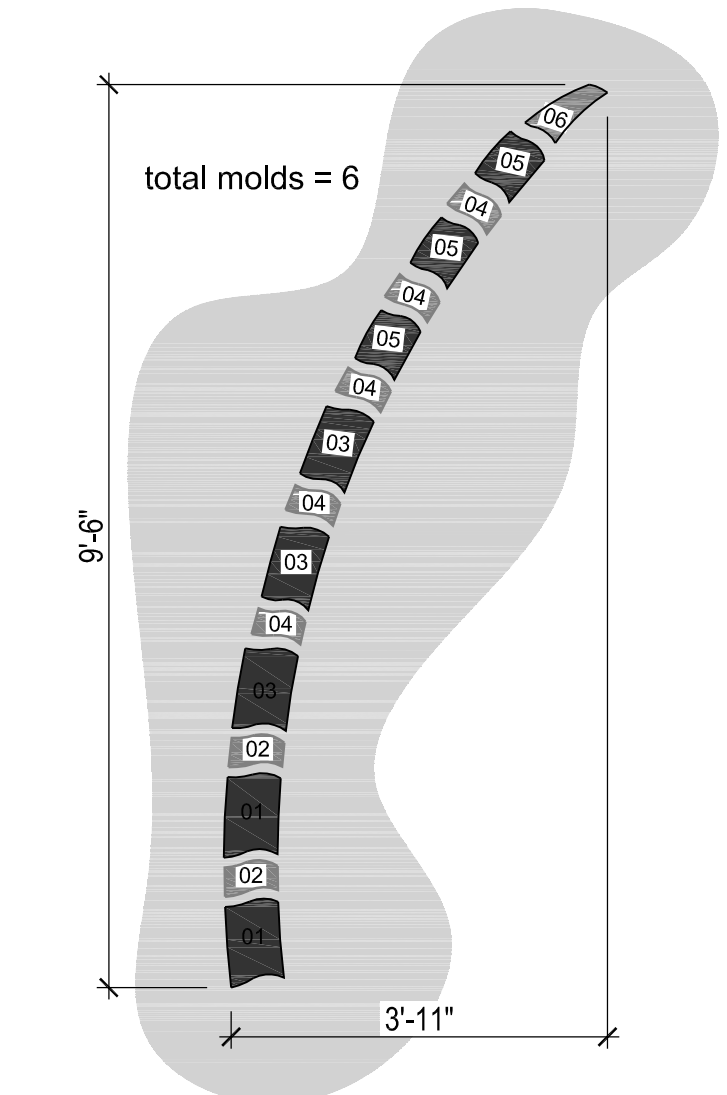


3 ELEVATION
BATHROOM FLOOR PALM DETAIL
SCALE: 1/2" = 1'-0"

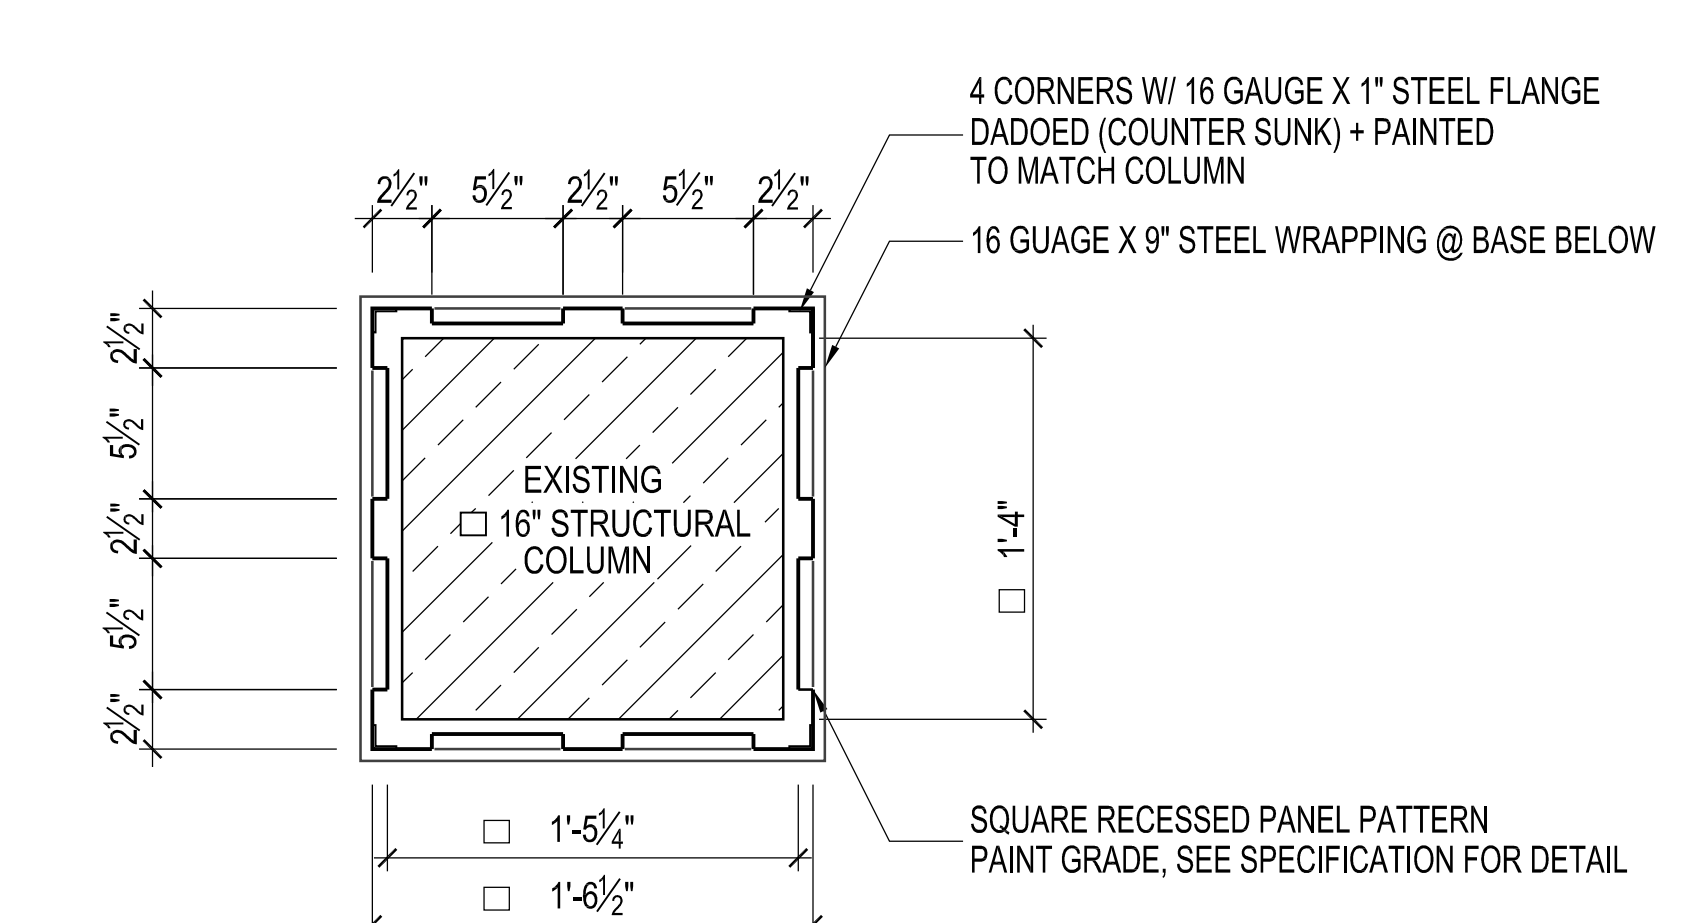

6 PLAN VIEW
WOOD COLUMN CLADDING (REF SHEET I0.01)
SCALE: 1-1/2" = 1'-0"

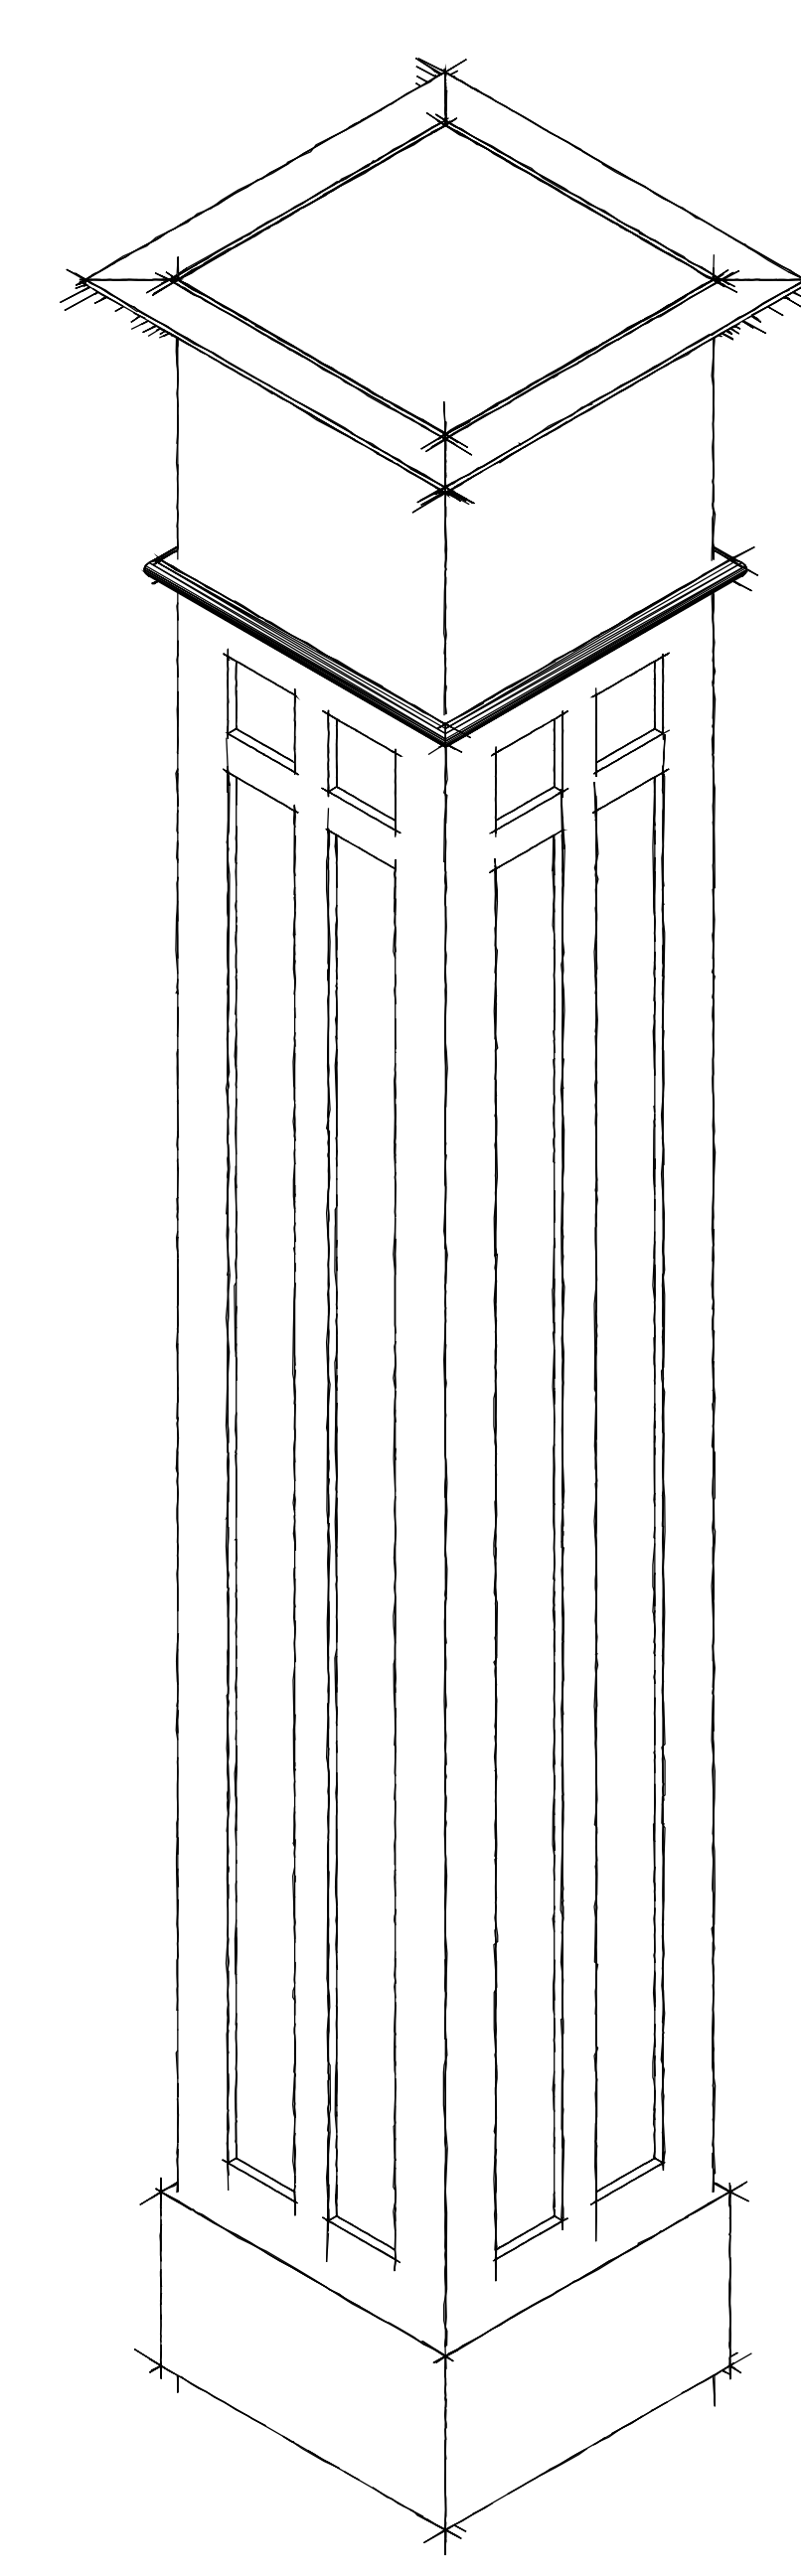


5 ISOMETRIC VIEW
WOOD COLUMN CLADDING
SCALE: 1-1/2" = 1'-0"

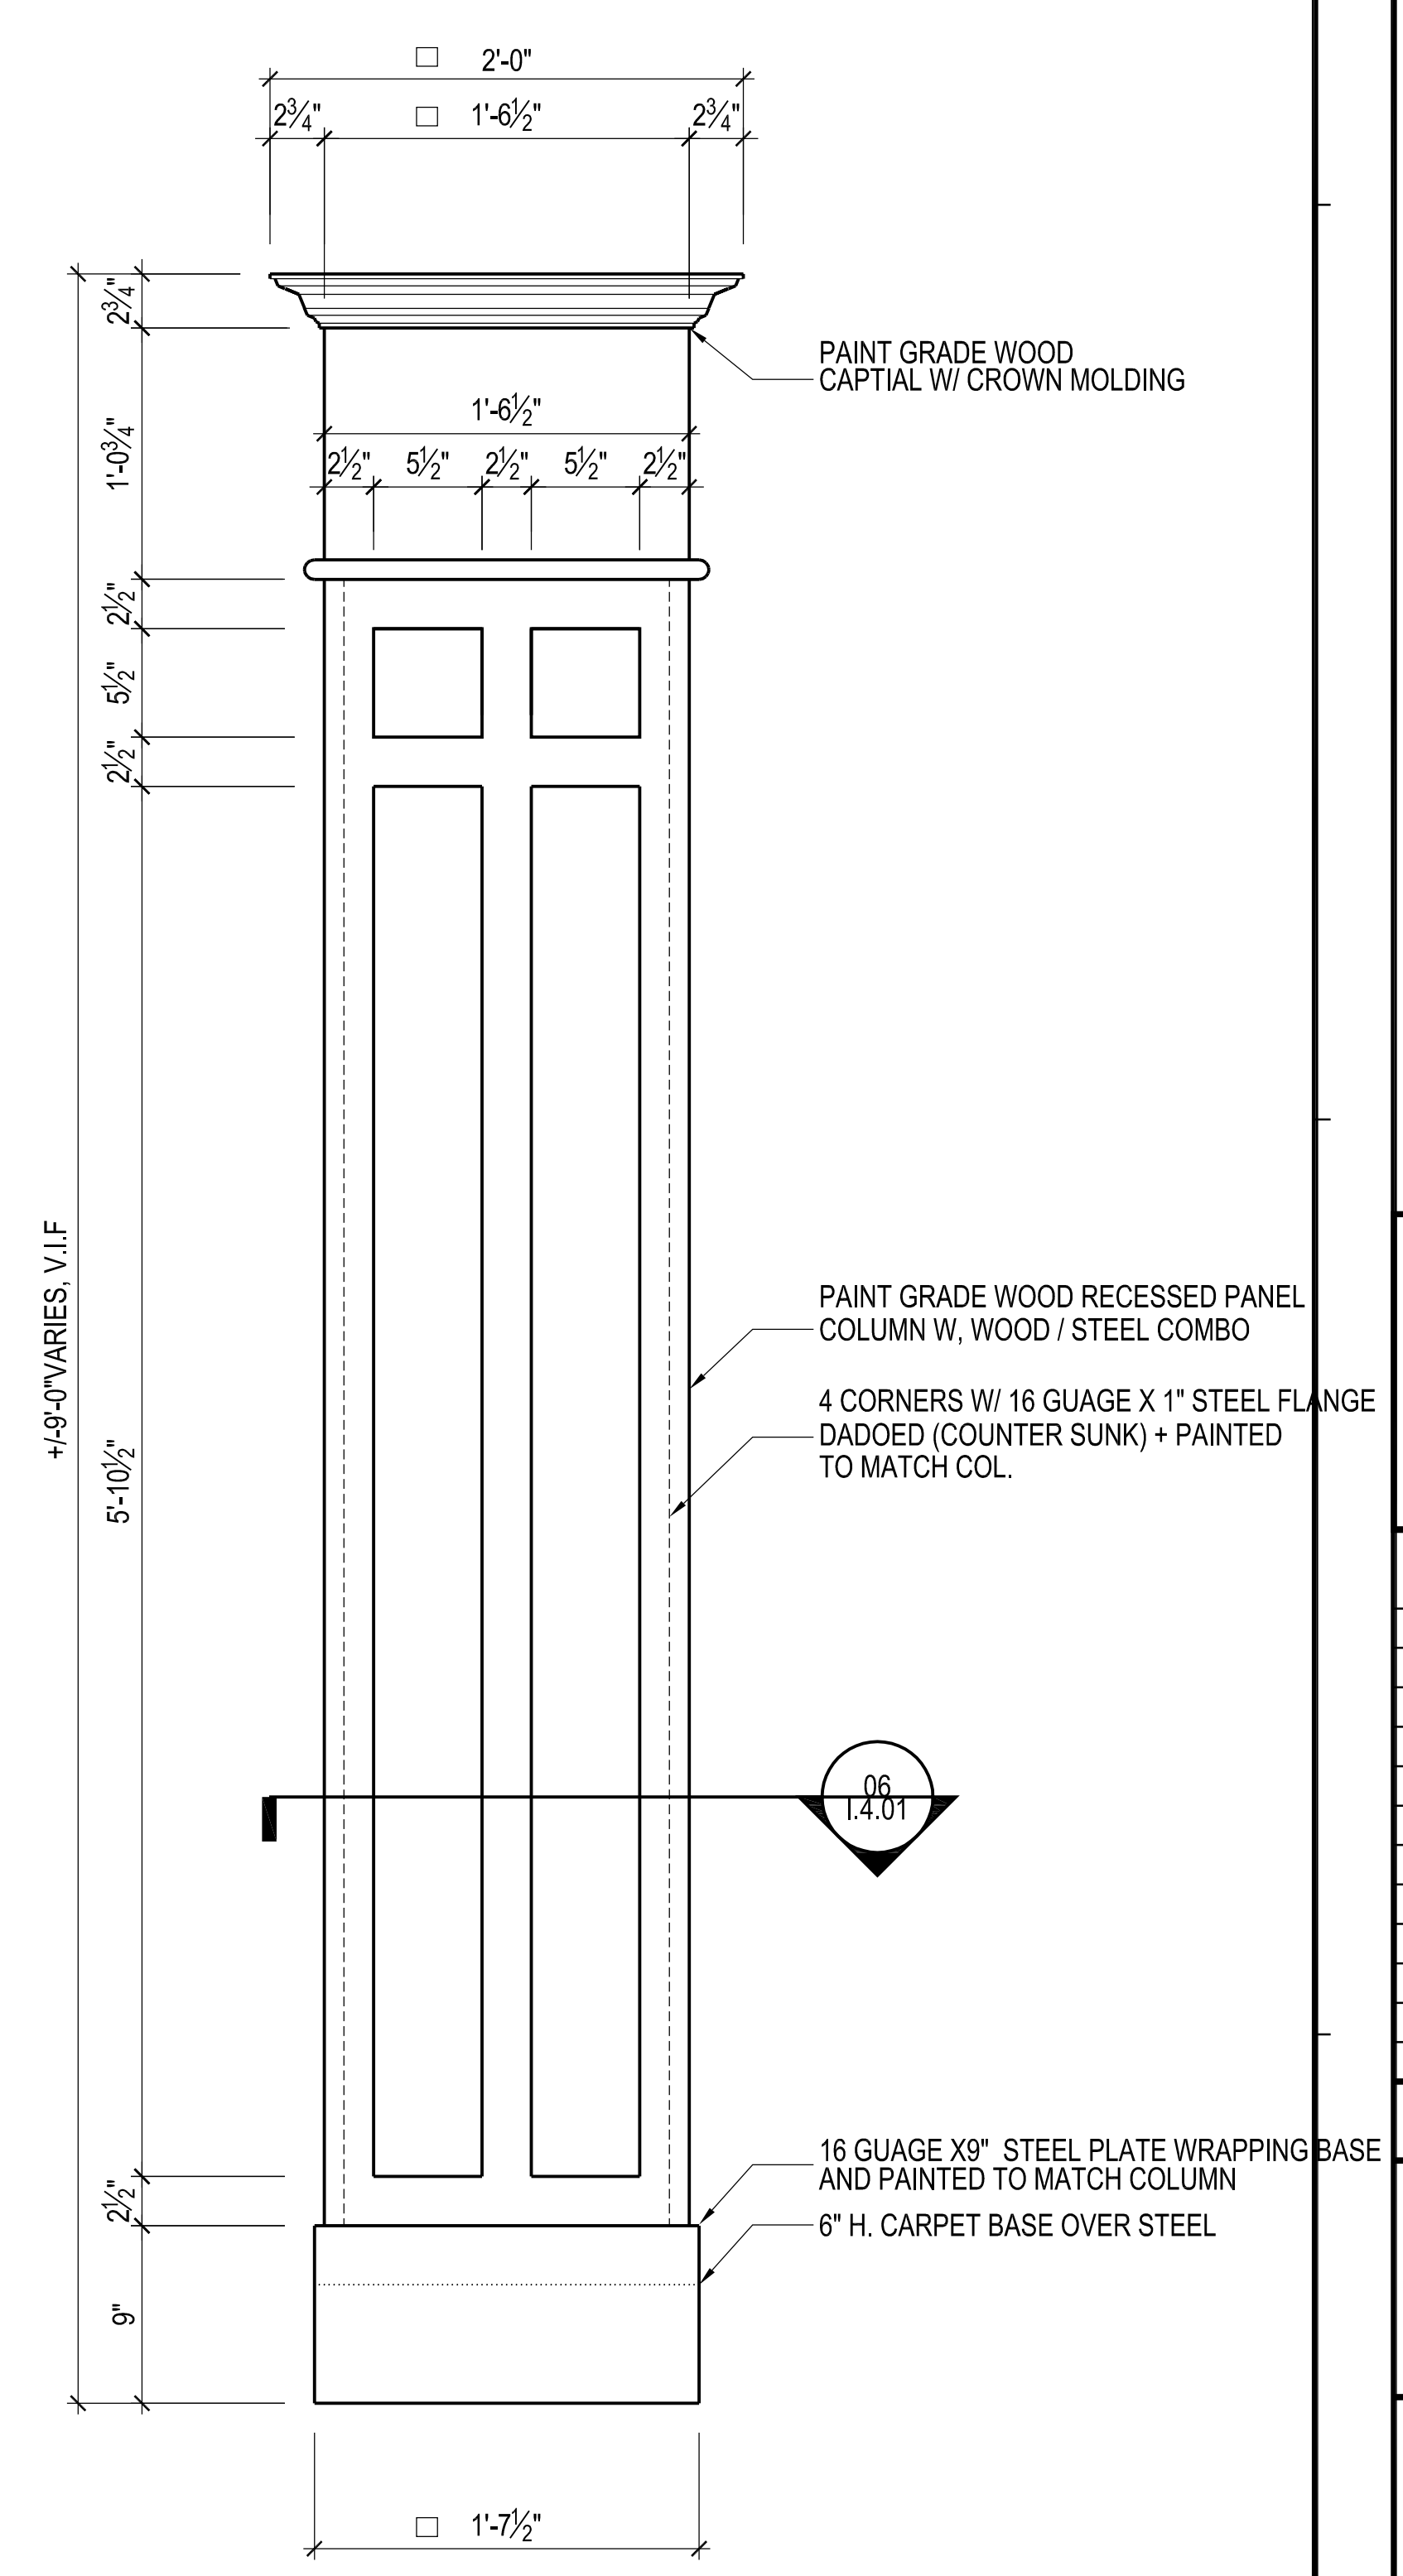

4 ELEVATION
WOOD COLUMN CLADDING
SCALE: 1-1/2" = 1'-0"

TERMINAL IMPROVEMENT PROJECT PHASE 1

KEY PLAN

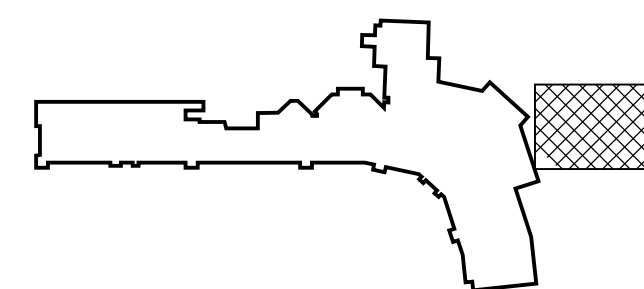

REVISIONS

No.	Description	Date	By

Designed by: _____ Drawn by: _____ Checked by: _____

Project Name: **TERMINAL IMPROVEMENT PROJECT PHASE 1**

Drawing Name: **GATE 2-6 BATHROOMS DETAILS**

LPA Project Number: **AR178005.8** FAA ASP Project Number: _____
Date: **AUGUST 31, 2007** Division: _____

Drawing Number: **14.01**