

PERIMETER WALK LEGEND - TILE FINISHES

- NOTE:**
- EMPIRE TILE MUST MATCH EXISTING EMPIRE SERIES!
- T11 TILE 11: "CROSSVILLE EMPIRE" (28"x14" VS77) PARISIAN WHITE MATT (UP)
 - T12 TILE 12: "CROSSVILLE EMPIRE" (28"x14" VS77) EMPERORS GOLD MATT(UP)
 - T13 TILE 13: "CROSSVILLE EMPIRE" (14"x14" VS84) LAUREL GREEN (UP)
 - T14 TILE 14 : "CROSSVILLE EMPIRE" (28"x14" VS77) PARISIAN WHITE PO.
 - 15 TILE 15 : 9'X9' MOSAIC (APPROX), SEE SPECIFICATIONS.
 - T16 TILE 16 : "CROSSVILLE EMPIRE" (7" x 7" VS77) PARISIAN WHITE MATT (UPS)
 - T17 TILE 17 : BULL NOSE MTM MASTERTILE BOTTICINO 3/4"x3/4"x12" OR APPROVED EQUAL (TRANSITION BETWEEN WALL TILE AND NEW DRY WALL ABOVE)
 - T18 TILE 18 : SAME AS T14 OVER EXISTING GLASS BLOCK WALL
 - WO: WALK OFF'S SEE SPECIFICATIONS

PERIMETER WALK LEGEND - PAINT FINISHES

- P 11: SHERWIN WILLIAMS LATEX ACRYLIC "PROMAR 200", SATIN, (MATCH EXISTING)
- P 12: SHERWIN WILLIAMS LATEX ACRYLIC "PROMAR 200", SATIN, (MATCH EXISTING)
- P 13: SHERWIN WILLIAMS LATEX ACRYLIC "PROMAR 200", SATIN, (MATCH EXISTING)



GENERAL NOTES:

- A. SIDES OF ALL BRIDGES - P11
- B. ALL SIDES & TRIANG. SKYLIGHTS RECEIVE P13
- G.C. RESPONSIBLE FOR DEMOLITIONING EXISTING EXISTING FLOOR TILE + SLAB PREP FOR NEW TILE, WHEREVER NEW FLOOR TILE INDICATED.
- G.C. TO TOUCH UP DOOR & WINDOW TRIM AS NEEDED IN PERIMETER WALKWAY.
- G.C. TO SUPPLY & APPLY FASTEN STAINLESS STEEL CORNER GUARDS TO ALL OUTSIDE CORNERS OF LEVEL 1 TERMINAL, UP TO 8'-0" AFF OR CLNG (WHICHEVER IS LOWER). PUBLIC AREAS ONLY. SEE TECH. SPECS FOR FABRICATION.
- NOTE: SCALES INDICATED ARE ONLY VALID AT FULL SIZE PRINT (30"x42")!


LIFE SAFETY AND ELECTRICAL LEGEND

- A STROBE LIGHT/HORN
- B FIRE ALARM/ PULL
- C FIRE EXTINGUISHER CAB.
- D DUPLEX OUTLET
- E PHONE JACKS
- F THERMOSTAT SWITCH
- G SIGN
- H FIRE SHUTTER
- I DUPLEX OUTLET DIRECT CONNECT TO SMART CART
- J BLANK PLATE
- K BLANK DUPLEX
- L 8X8 EXHAUST FAN


NOTE: TILE CONTRACTOR IS RESPONSIBLE FOR COORDINATION OF A CONTINUOUS TILE & GROUT PATTERN AT LINE OF TRANSITION OF ALL DOOR OPENINGS LEADING INTO THE TERMINAL.

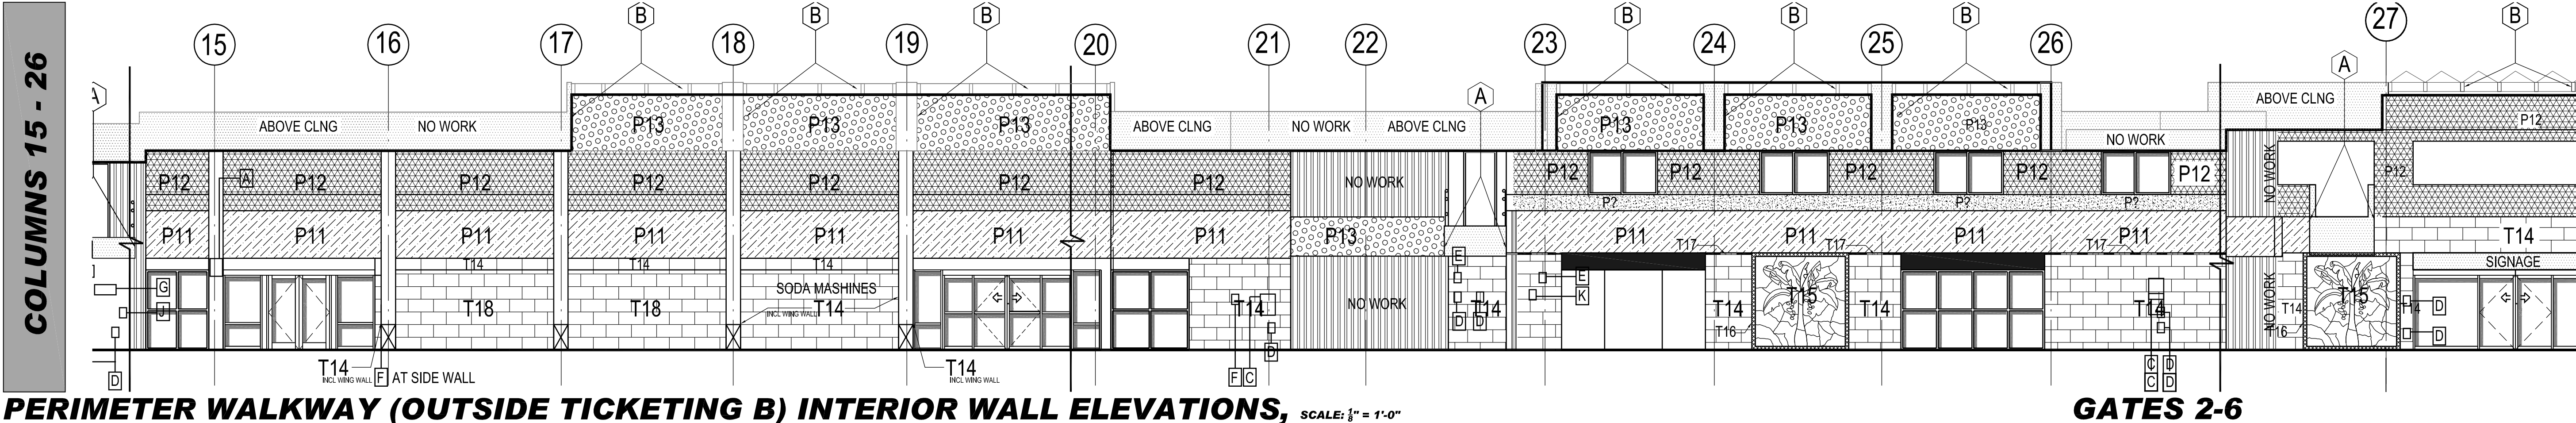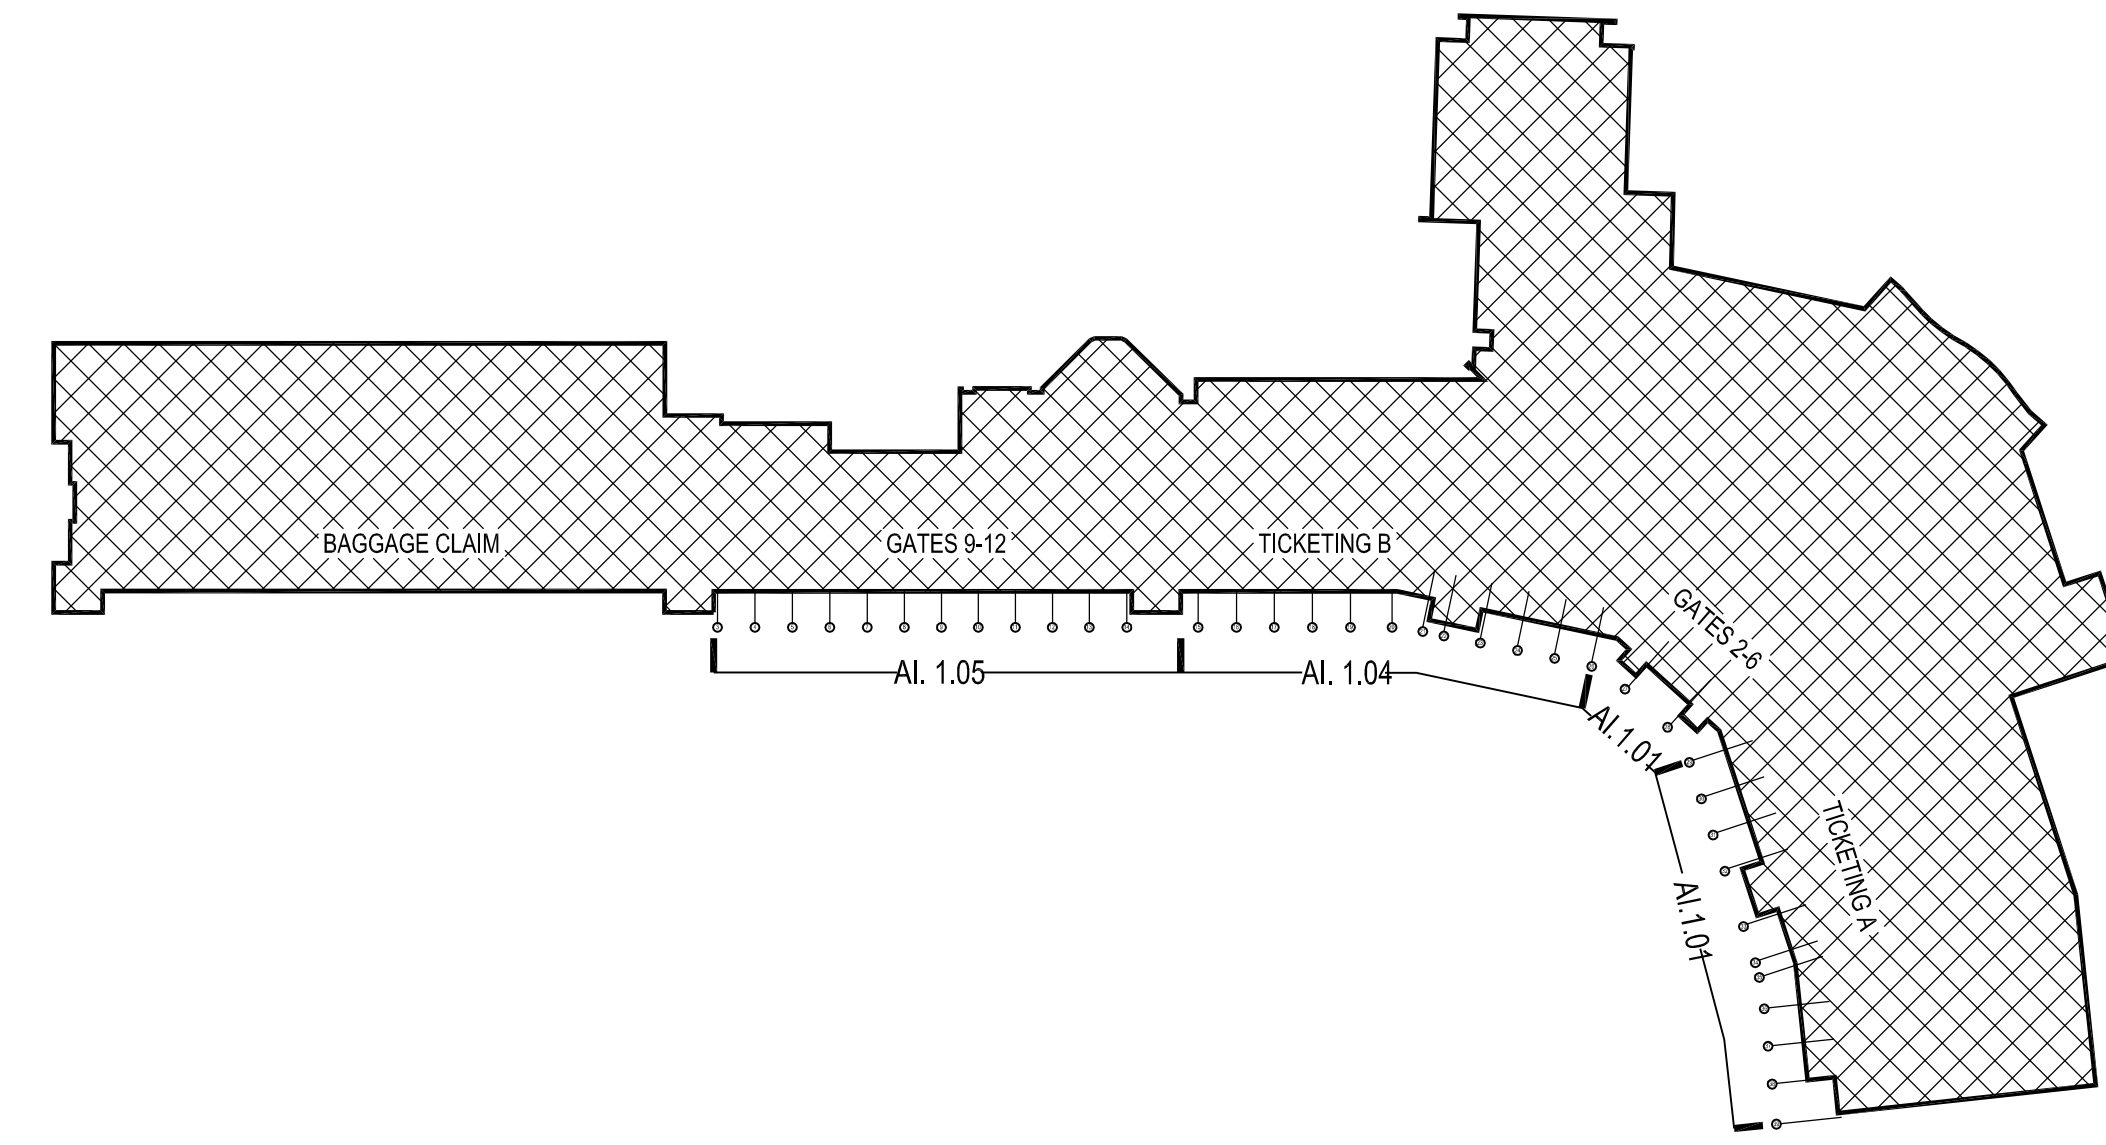

PERIMETER WALKWAY (OUTSIDE TICKETING B) INTERIOR WALL ELEVATIONS, SCALE: 1/8" = 1'-0"

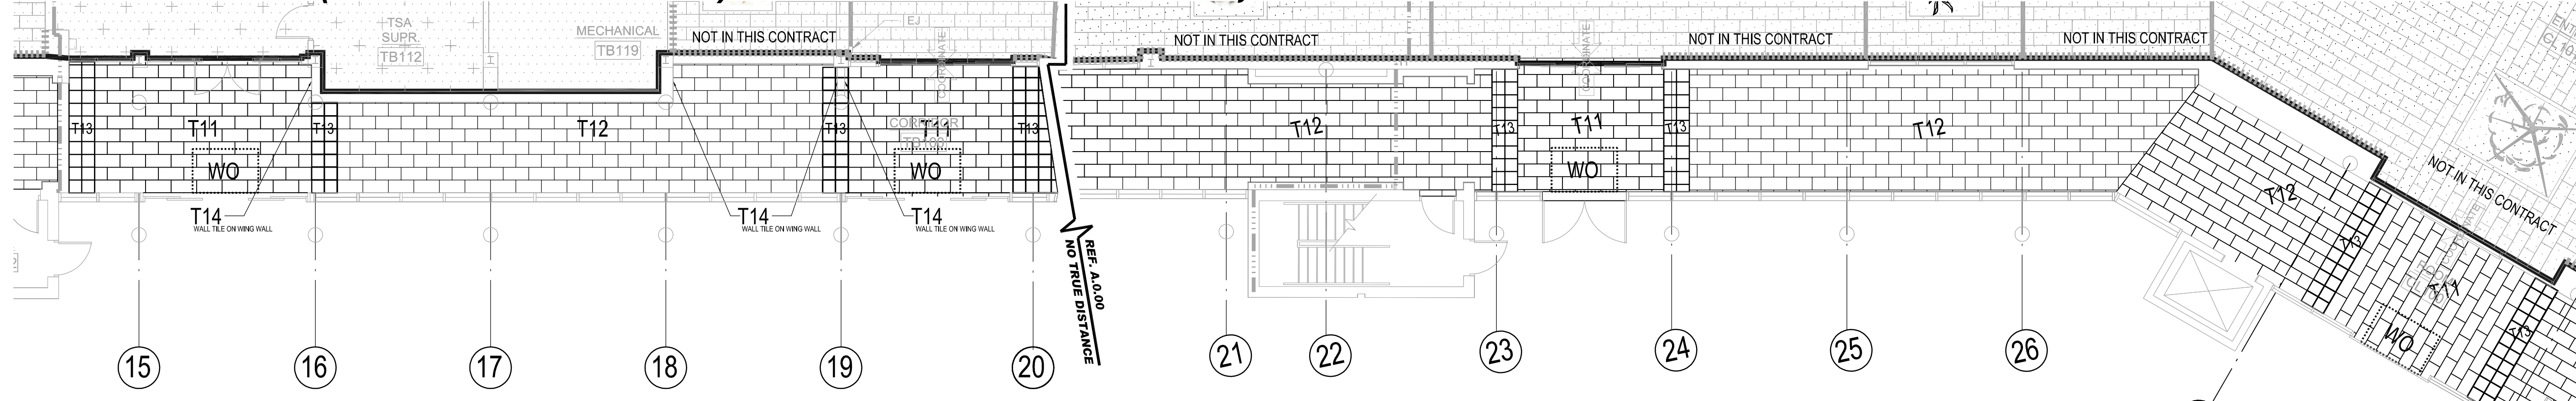

PERIMETER WALKWAY (OUTSIDE TICKETING B) FLOOR PLAN, SCALE: 1/8" = 1'-0"

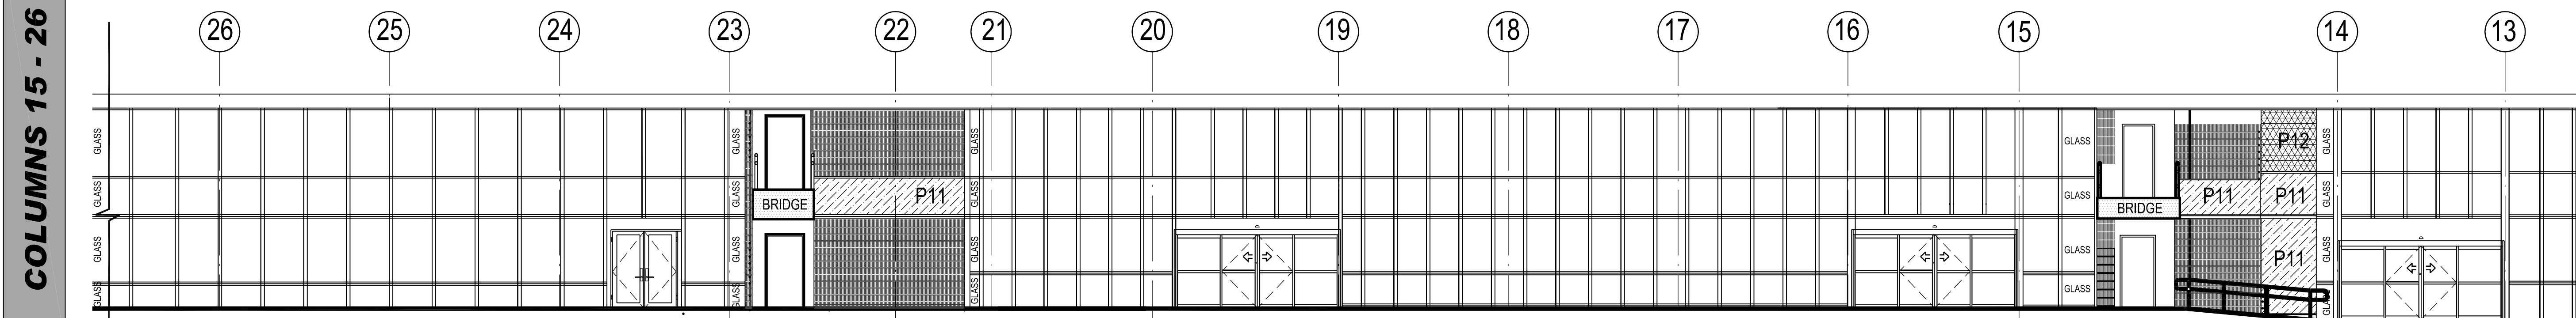

PERIMETER WALKWAY (OUTSIDE TICKETING B) CURTAIN WALL ELEVATIONS, SCALE: 1/8" = 1'-0"

**ECONOMIC STIMULUS PROJECT
THE PERIMETER WALKWAY**

REVISIONS			
No.	Description	Date	By

Designed by: _____ Drawn by: _____ Checked by: _____

Project Name: _____

**TICKETING B
FINISHES**

LPA Project Number: **AR178014** FAA AIP Project Number: _____
Date: **04.02.2009** Division: _____

WI-1.04