

PERIMETER WALK LEGEND - TILE FINISHES

NOTE: _____

EMPIRE TILE MUST MATCH EXISTING EMPIRE SERIES I

- T11 TILE 11: "CROSSVILLE EMPIRE" (28"x14" VS77) PARISIAN WHITE MATT (UP)
- T12 TILE 12: "CROSSVILLE EMPIRE" (28"x14" VS77) EMPERORS GOLD MATT(UP)
- T13 TILE 13: "CROSSVILLE EMPIRE" (14"x14" VS84) LAUREL GREEN (UP)
- T14 TILE 14 : "CROSSVILLE EMPIRE" (28"x14" VS77) PARISIAN WHITE PO.
- 15 TILE 15 : 9'X9' MOSAIC (APPROX), SEE SPECIFICATIONS.
- T16 TILE 16 : "CROSSVILLE EMPIRE" (7" x 7" VS77) PARISIAN WHITE MATT (UPS)
- T17 TILE 17 : BULL NOSE MTM MASTERTILE BOTTCINO 3/4"X3/4"X1/2" OR APPROVED EQUAL (TRANSITION BETWEEN WALL TILE AND NEW DRY WALL ABOVE)
- T18 TILE 18 : SAME AS T14 OVER EXISTING GLASS BLOCK WALL

PERIMETER WALK LEGEND - PAINT FINISHES

- P11 P 11: SHERWIN WILLIAMS LATEX ACRYLIC "PROMAR 200", SATIN, (MATCH EXISTING)
- P12 P 12: SHERWIN WILLIAMS LATEX ACRYLIC "PROMAR 200", SATIN, (MATCH EXISTING)
- P13 P 13: SHERWIN WILLIAMS LATEX ACRYLIC "PROMAR 200", SATIN, (MATCH EXISTING)

GENERAL NOTES:

- A. SIDES OF ALL BRIDGES - P11
- B. ALL SIDES & TRIANG. SKYLIGHTS RECEIVE P13


- G.C. RESPONSIBLE FOR DEMOLITIONING EXISTING EXISTING FLOOR TILE + SLAB PREP FOR NEW TILE, WHEREVER NEW FLOOR TILE INDICATED.
 - G.C. TO TOUCH UP DOOR & WINDOW TRIM AS NEEDED IN PERIMETER WALKWAY.
 - G.C. TO SUPPLY & APPLY FASTEN STAINLESS STEEL CORNER GUARDS TO ALL OUTSIDE CORNERS OF LEVEL I TERMINAL, UP TO 8'-0" AFF OR CLNG (WHICHEVER IS LOWER), PUBLIC AREAS ONLY. SEE TECH. SPECS FOR FABRICATION.
 NOTE: SCALES INDICATED ARE ONLY VALID AT FULL SIZE PRINT (30"x42")!

LIFE SAFTY AND ELECTRICAL LEGEND



- A STROBE LIGHT/HORN
- B FIRE ALARM/ PULL
- C FIRE EXTINGUISHER CAB.
- D DUPLEX OUTLET
- E PHONE JACKS
- F THERMOSTAT SWITCH
- G SIGN
- H FIRE SHUTTER
- I DUPLEX OUTLET DIRECT CONNECT TO SMART CART
- J BLANK PLATE
- K BLANK DUPLEX
- L 8X8 EXHAUST FAN

NOTE: COORDINATE

TILE CONTRACTOR IS RESPONSIBLE FOR COORDINATION OF A CONTINUOUS TILE & GROUT PATTERN AT LINE OF TRANSITION OF ALL DOOR OPENINGS LEADING INTO THE TERMINAL.

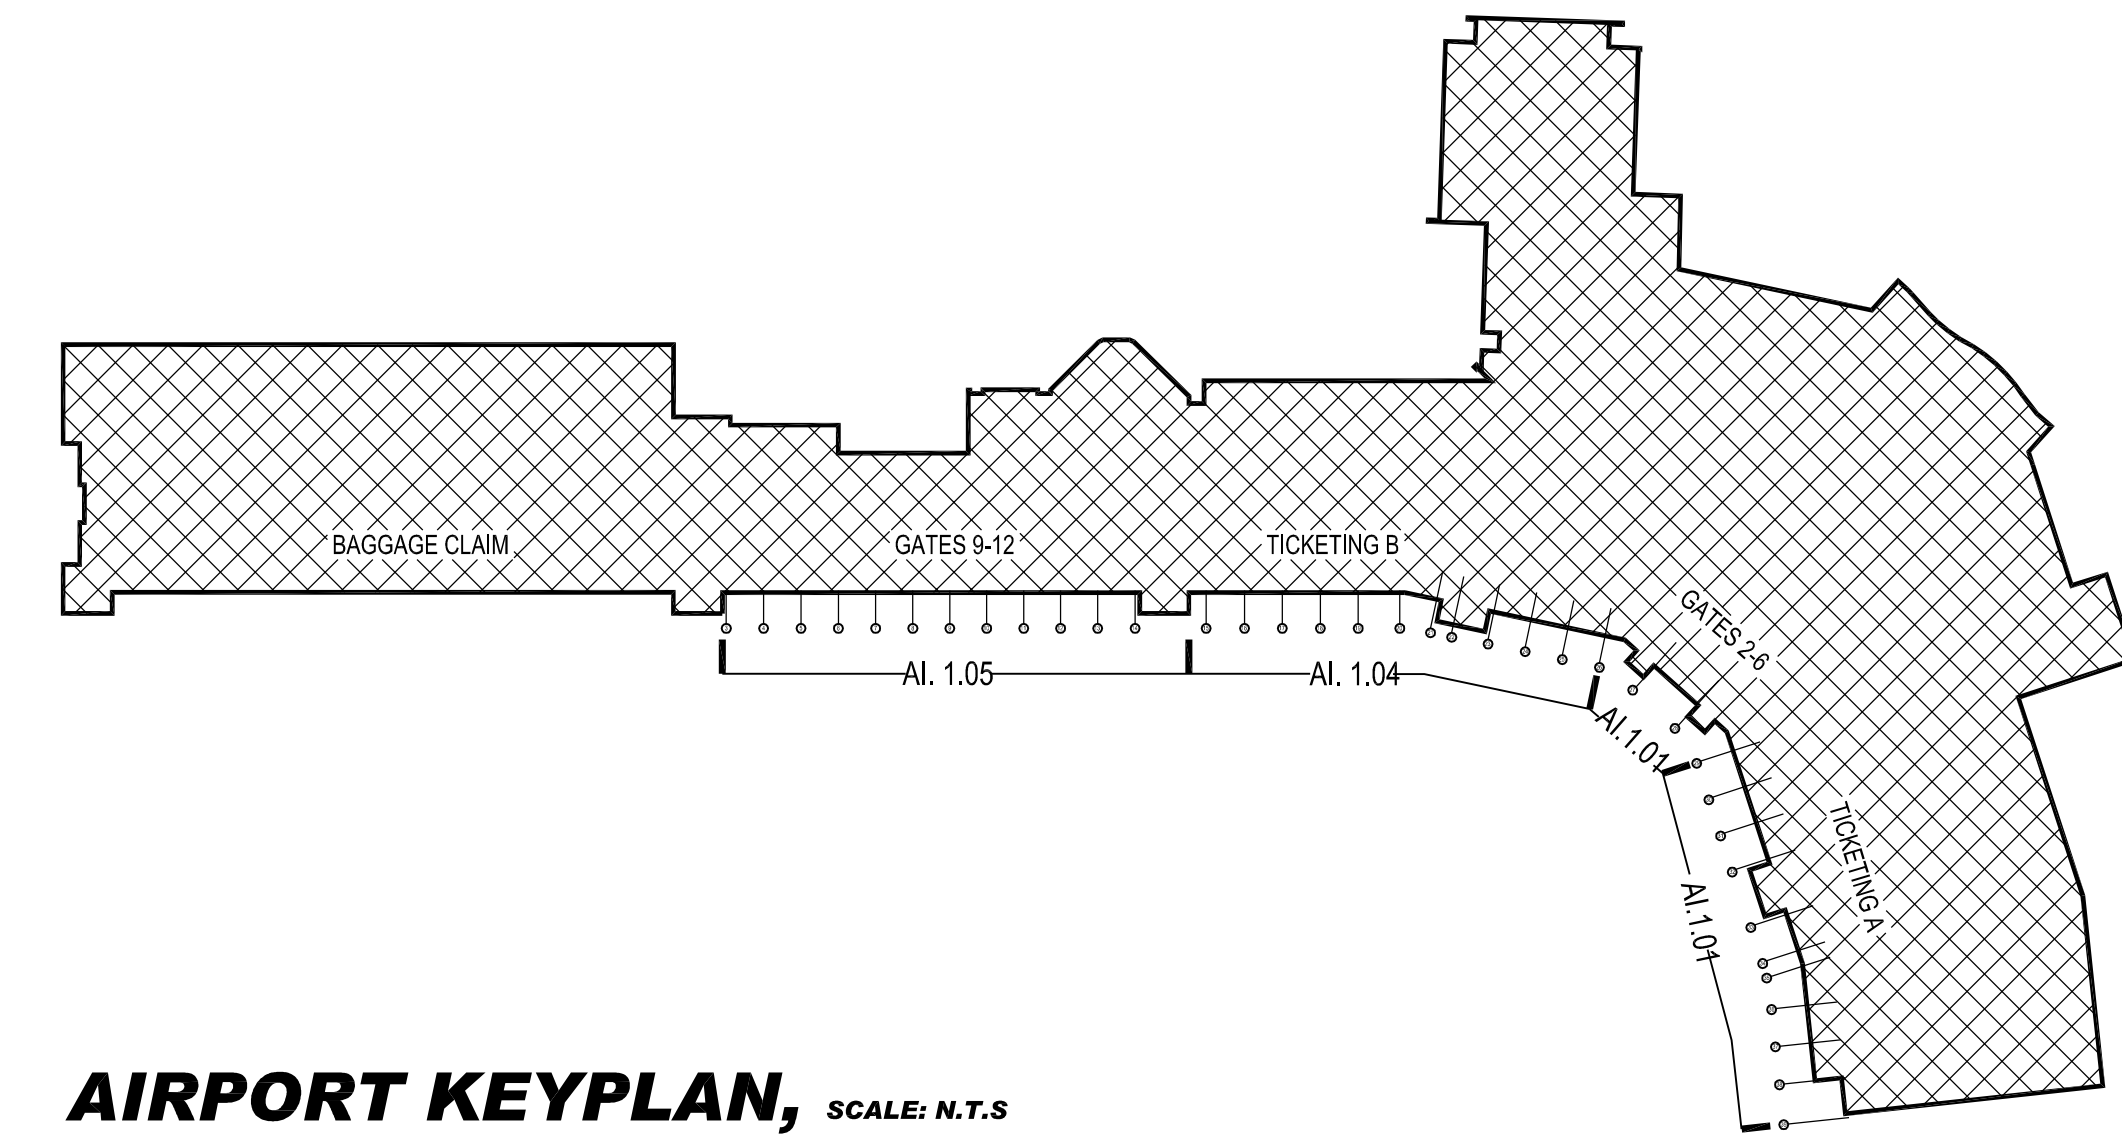


AIRPORT KEYPLAN, SCALE: N.T.S.

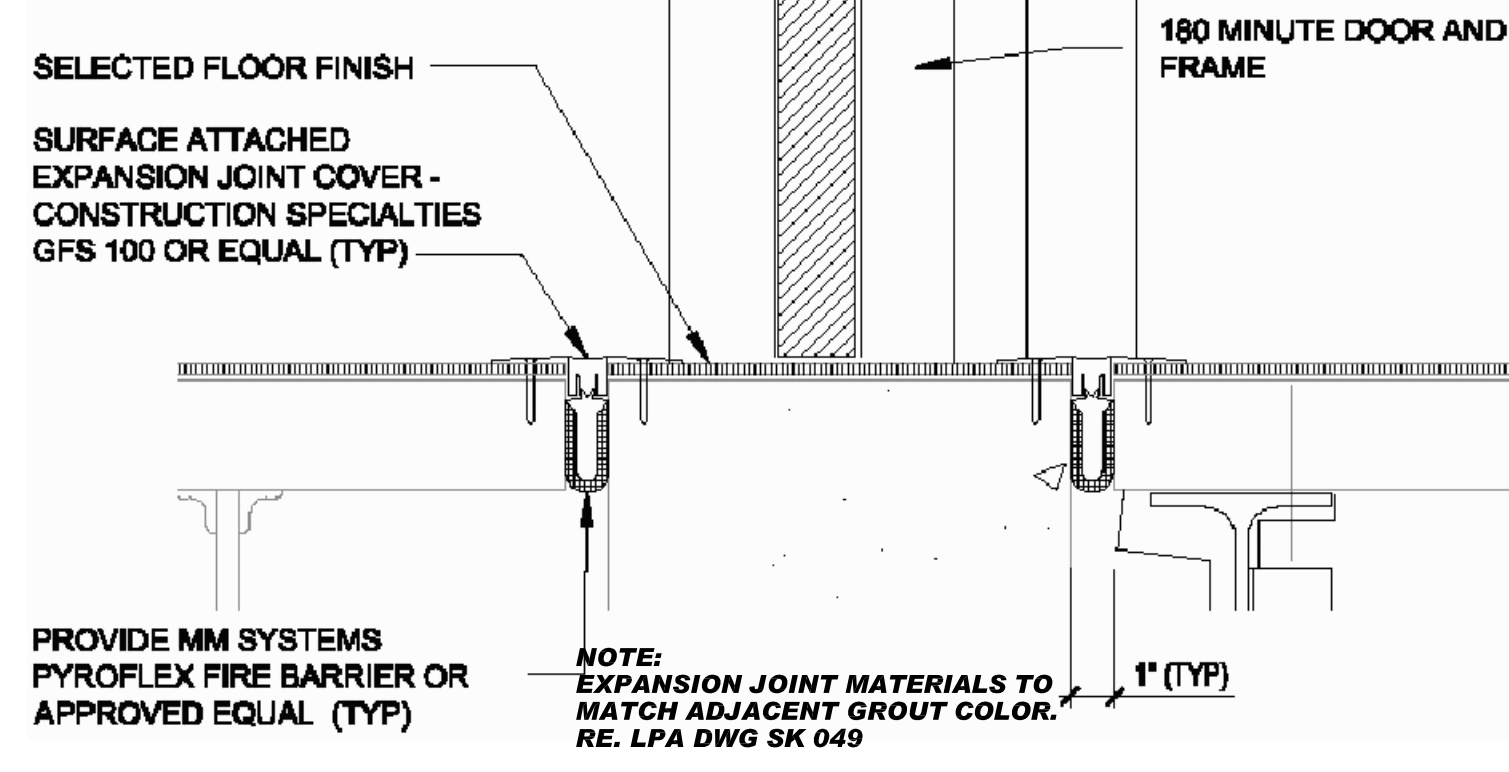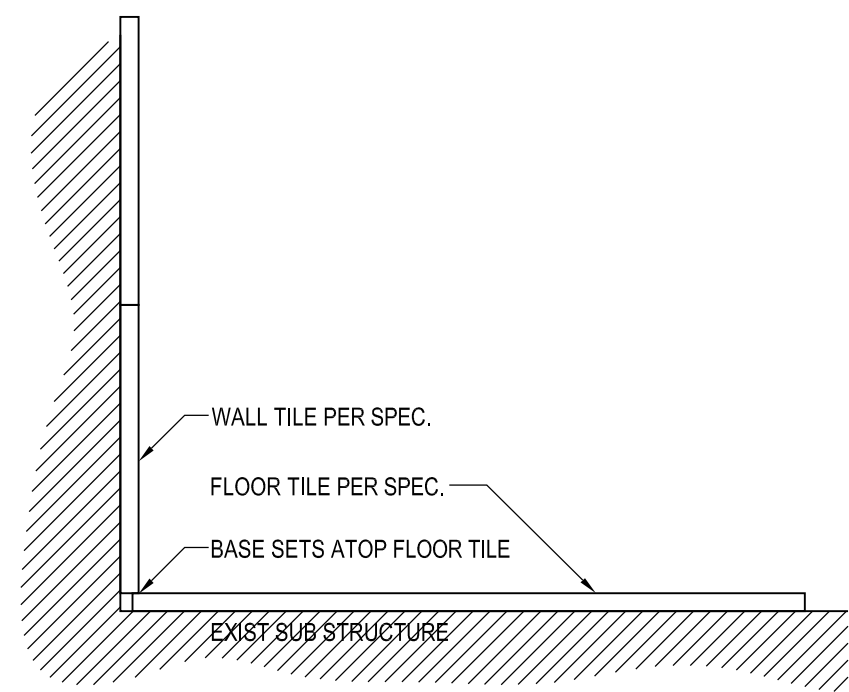


**TYPICAL, ALL DRAWINGS!
DETAIL: TILE WALL/TILE FLOOR, SCALE: N.T.S.**


**TYPICAL, ALL DRAWINGS!
DETAIL: EXPANSION JOINT, SCALE: N.T.S.**

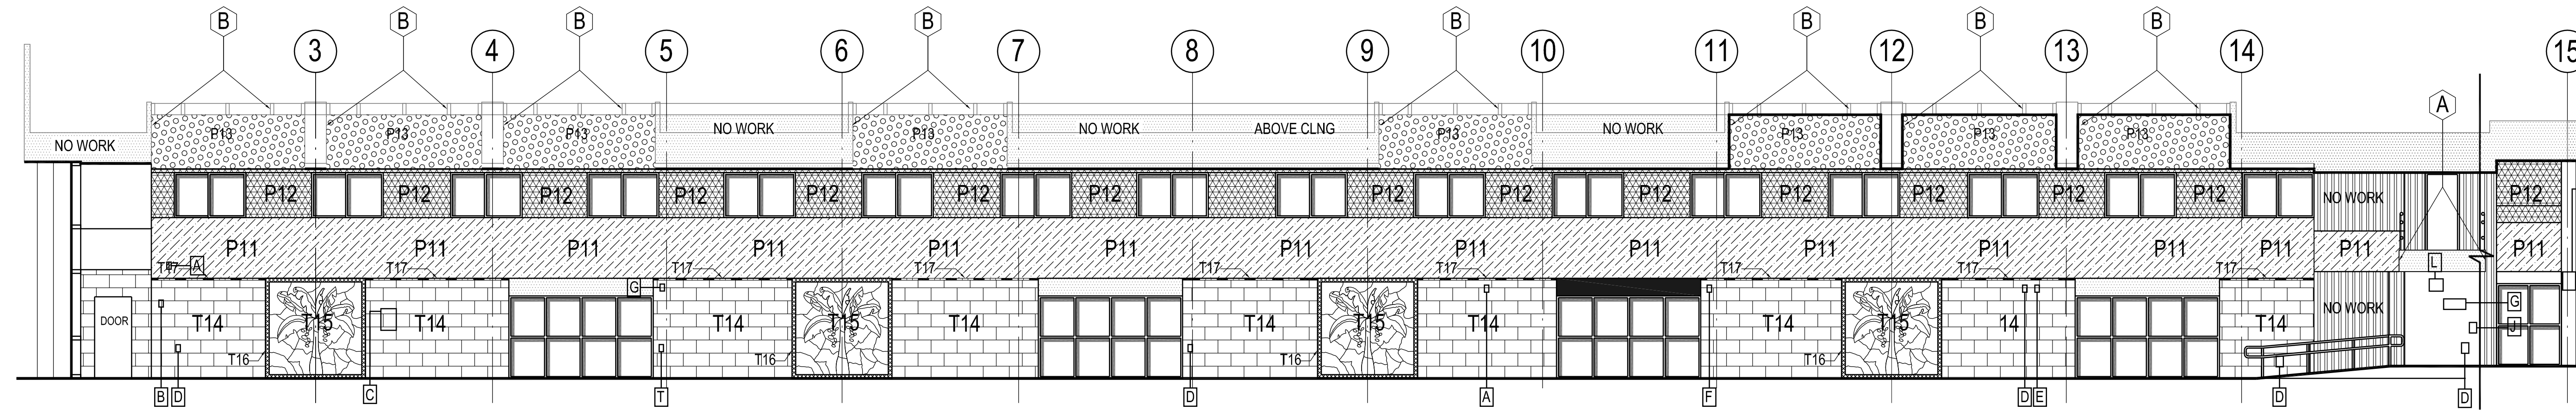

PERIMETER WALKWAY (OUTSIDE GATES 9-12) INTERIOR WALL ELEVATIONS, SCALE: 1/8" = 1'-0"

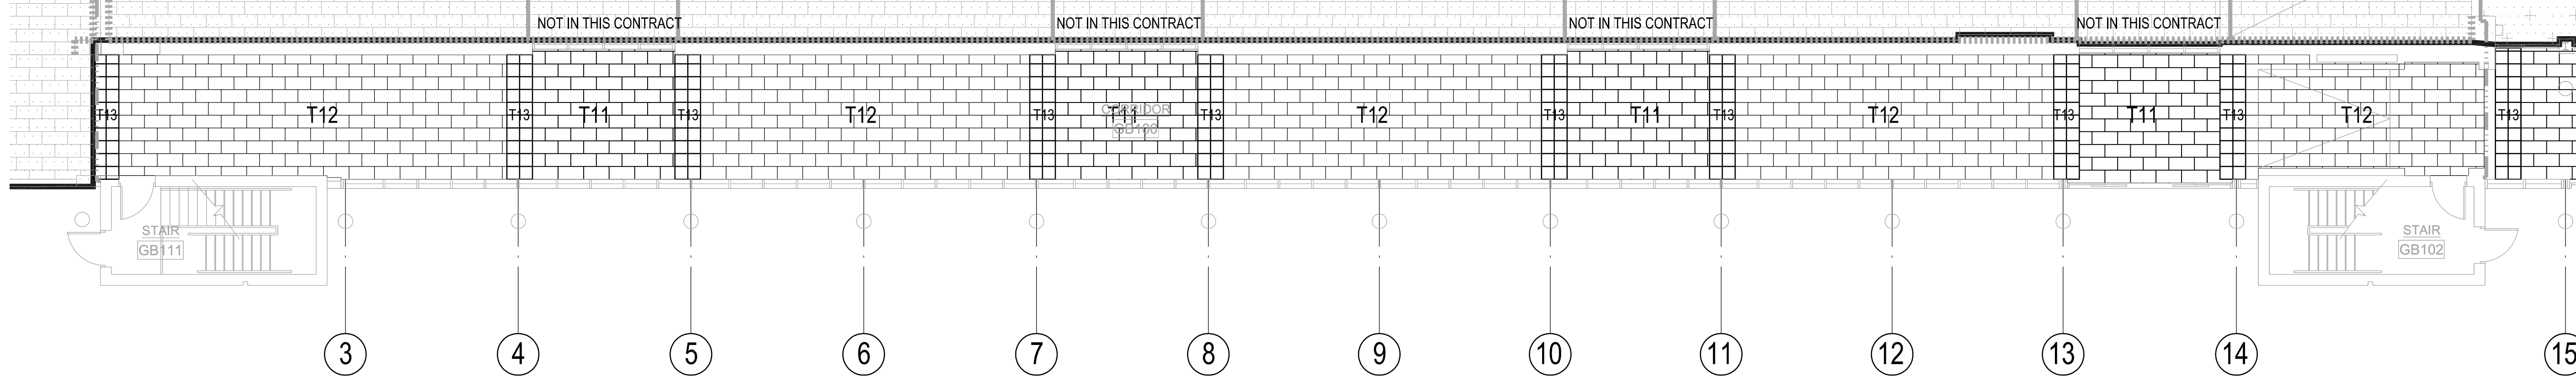

PERIMETER WALKWAY (OUTSIDE GATES 9-12) FLOOR PLAN, SCALE: 1/8" = 1'-0"

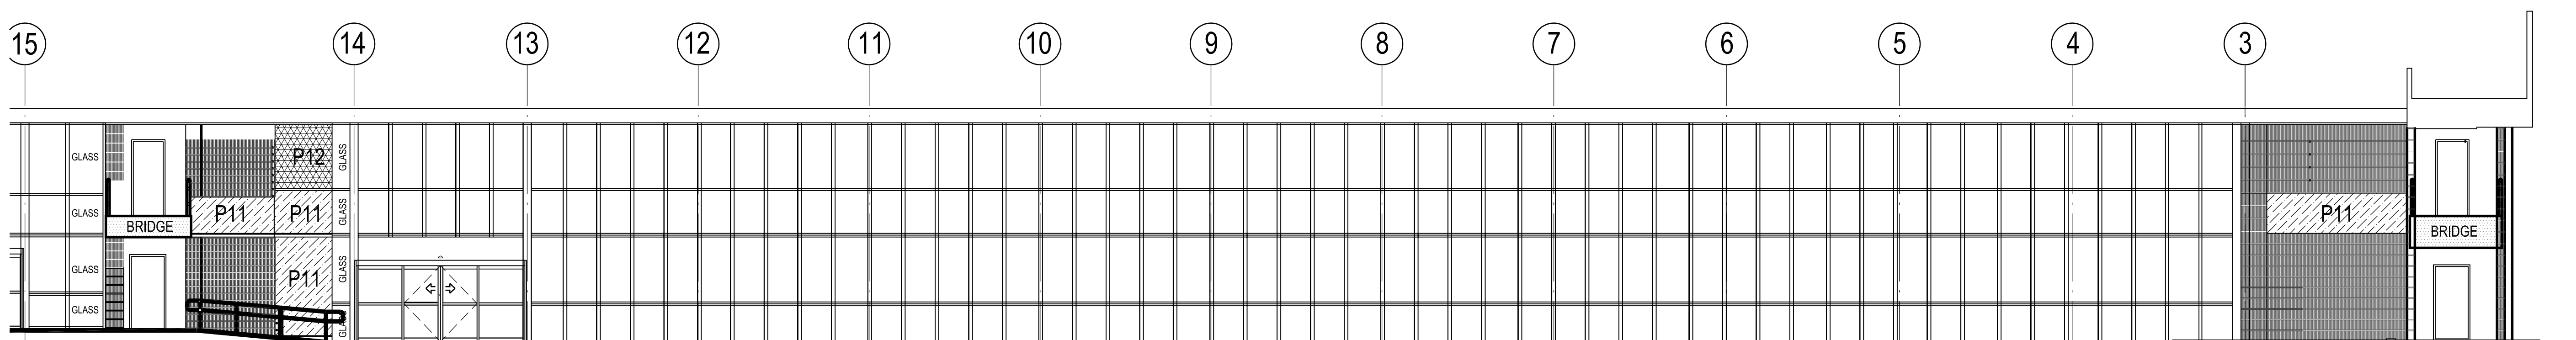

PERIMETER WALKWAY (OUTSIDE GATES 9-12) CURTAIN WALL ELEVATIONS, SCALE: 1/8" = 1'-0"

**ECONOMIC STIMULUS PROJECT
THE PERIMETER WALKWAY**

REVISIONS

No.	Description	Date	By

Designed by: _____ Drawn by: _____ Checked by: _____

Project Name: _____

Drawing Name: _____

**GATES 9-12
FINISHES**

LPA Project Number: **AR178014** FAA AEP Project Number: _____

Date: **04.02.2009** Division: _____

Drawing Number: _____

WI-1.05