

GENERAL NOTE:

CONTRACTOR TO REMOVE ANY EXISTING WALL COVER, REPAIR AND PREP WALLS
AND REINSTALL NEW WALL COVER IN AREAS AS NOTED ON SCHEDULES AND DRAWINGS.

REFERENCE SHEETS I.1.01/I.1.02/I.1.04/I.1.05/I.1.07/I.4.01/I.1.6.02/
A.1.11/A.1.15 FOR WALL COVER AND PAINT ONLY.

LEGEND - WALL FINISHES

WC 01 : (MAIN TERMINALS) 54" VINYL NO REPEAT SEE SPECIFICATIONS (BOOK) FOR DETAILS .

WC 01 : (MAIN TERMINALS) IN GATES 2-6 AND TICKETING B AREAS "NEW CONSTRUCTION"

WC 02 : (GATES 2-6) 54" VINYL NO REPEAT SEE SPECIFICATIONS (BOOK) FOR DETAILS .

WC 03 : (LEVEL II RESTAURANT) FULL HGT. WALL @ 8'-0", 54" VINYL NO REPEAT SEE SPECIFICATIONS (BOOK) FOR DETAILS .

WC 03 : (LEVEL II RESTAURANT) HALF WALL SAME SPEC

WC 04 : (BAGGAGE CLAIM) 54" VINYL NO REPEAT SEE SPECIFICATIONS (BOOK) FOR DETAILS .


WC 05 : (LEVEL II RESTAURANT) 54" VINYL, SEE SPECIFICATIONS (BOOK) FOR DETAILS .

WALL TILE BY OTHERS

T6: TILE WAINSCOTT BY TILE CONTRACTOR, SUBSTRATE PROVIDED BY GC FOR "ECONOMIC STIMULUS PROJECT"

T7: TILE WAINSCOTT ON KNEEWALL (+/- 30" HGT, FIELD VERIFY) + SILL BY TILE CONTRACTOR, SUBSTRATE PROVIDED BY GC FOR "ECONOMIC STIMULUS PROJECT"

SEE SHEET #I.6.02 FINISH SCHEDULE FOR PAINT TYPES AND LOCATION

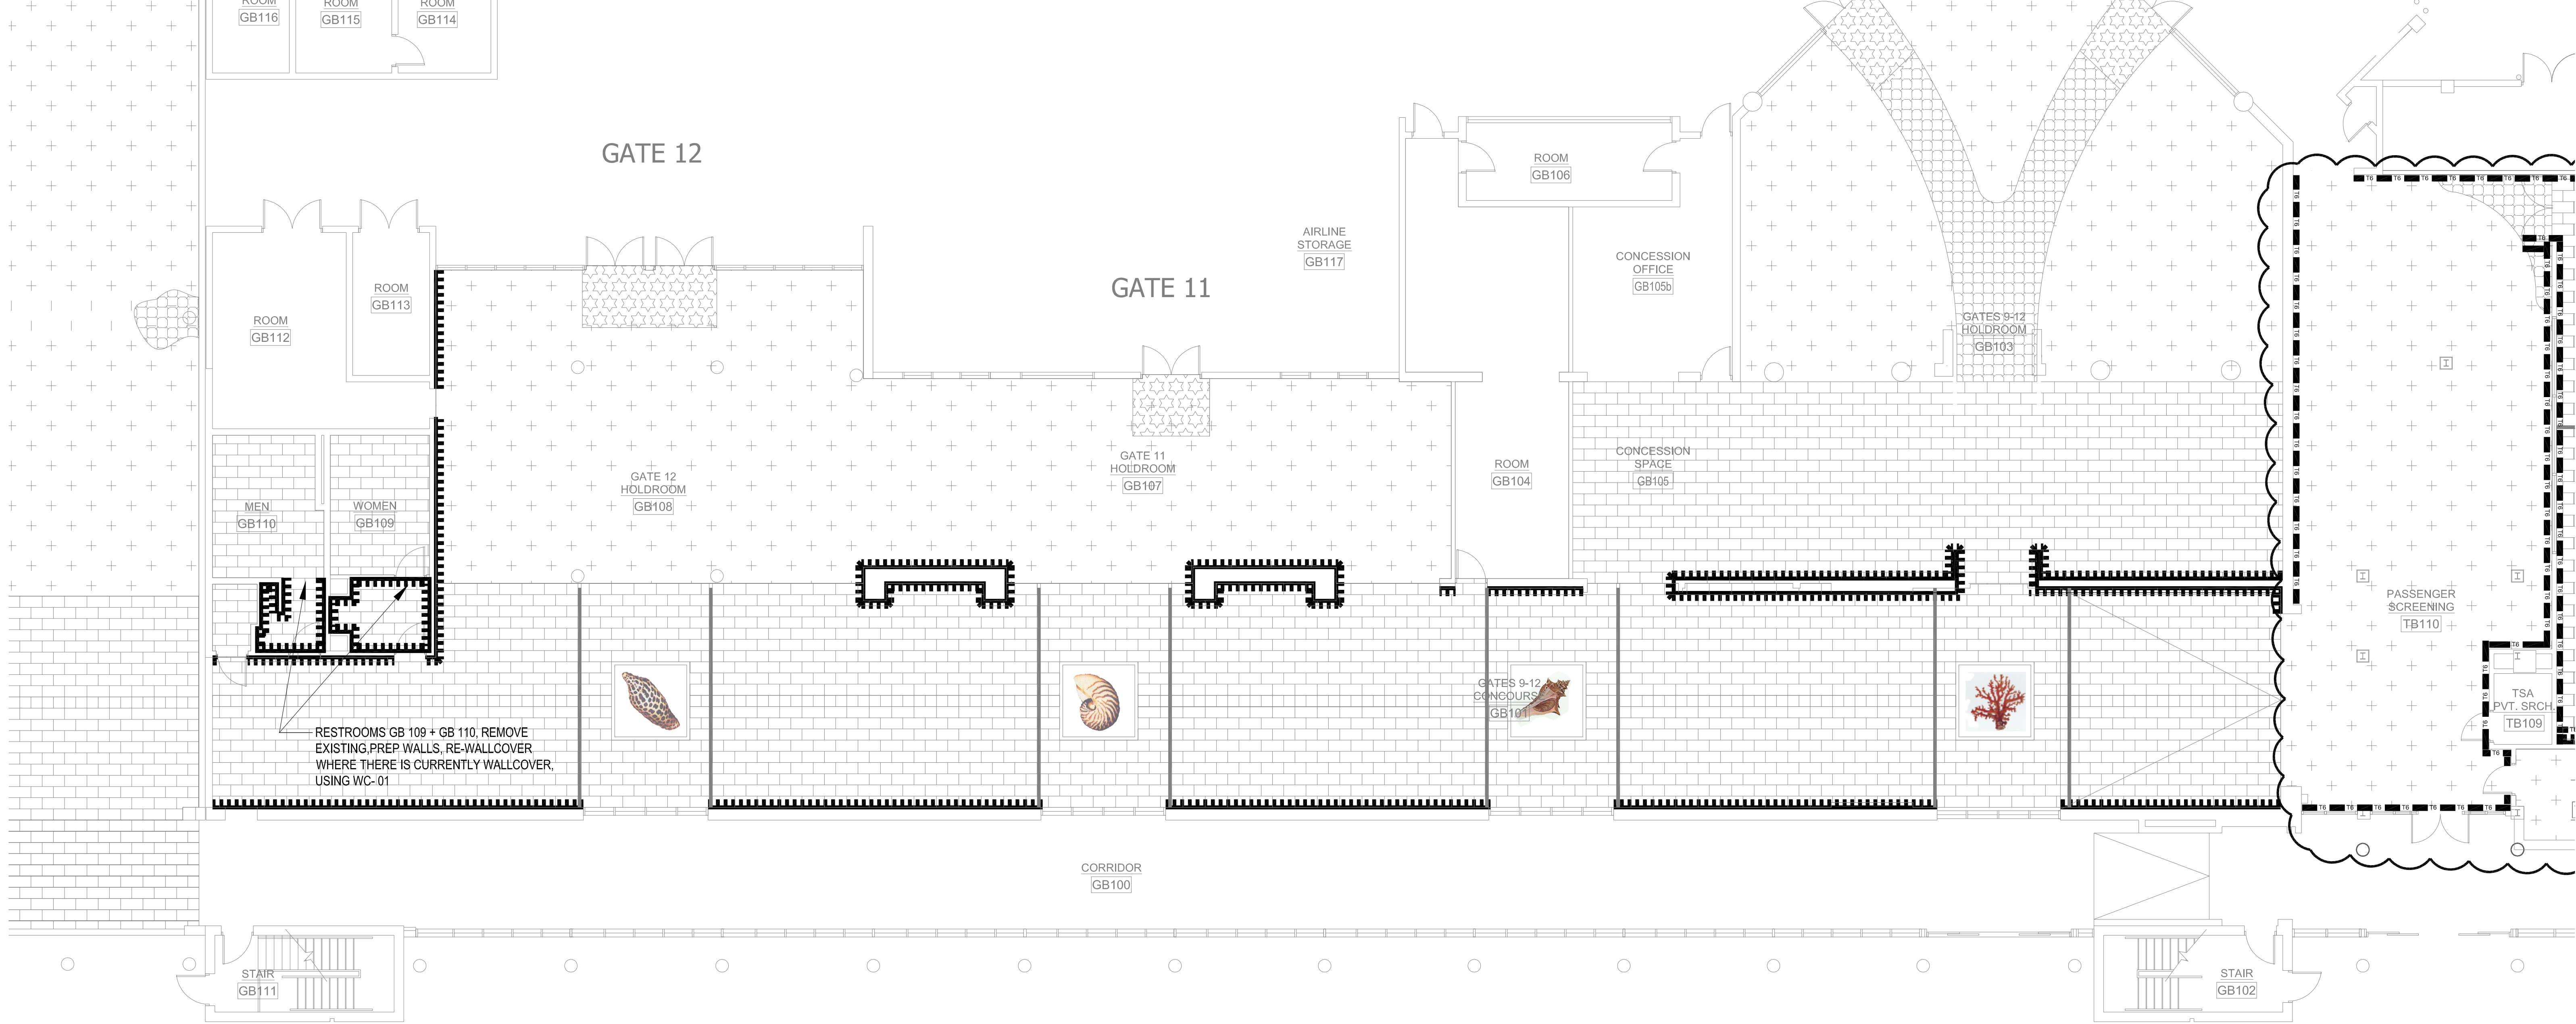

1
A0.01

FLOOR PLAN
GATES 9 - 12
SCALE: 1/8" = 1'-0"

St. Petersburg
Clearwater
International
Airport


THE LPA GROUP
ENGINEERS ARCHITECTS PLANNERS
700 HUGER STREET
COLUMBIA, SOUTH CAROLINA 29201
POST OFFICE BOX 5805
COLUMBIA, SOUTH CAROLINA 29250-5805
Phone: 803/254-2211 Fax: 803/779-0482
DENNIS J. WIEHA, FLORIDA ARCHITECT LICENSE # 11996
LPA GROUP INCORPORATED, FLORIDA LICENSE # A0000354



Lic ID: 0002709
FL # 13 001146
Kelly@kellytaafedesign.com
Tel: 813.695.5049
Fax: 813.805.2371

**TERMINAL IMPROVEMENT
PROJECT - WALL FINISHES**

KEY PLAN

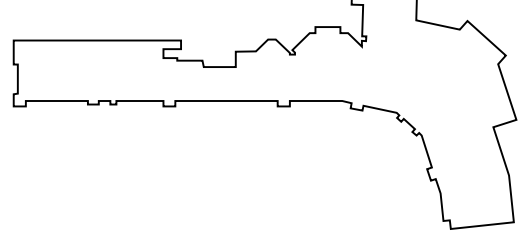

REVISIONS

No.	Description	Date	By
01	ADDENDUM 1	04/20/09	KTD

Designed by: Drawn by: Checked by:

Project Name:

**TERMINAL IMPROVEMENT
PROJECT
WALL COVER & PAINT**

Drawing Name:

**FLOOR PLAN
GATES 9-12**

LPA Project Number: AR178005.8 FAA AIP Project Number:

Date: 04 / 20/ 2009 Division :

Drawing Number: FP-ALL.dwg

I.1.05
10/16/2009 3:22:11
Released