


1 1st FLOOR RCP/ELEC
Scale: 1/4" = 1'-0"

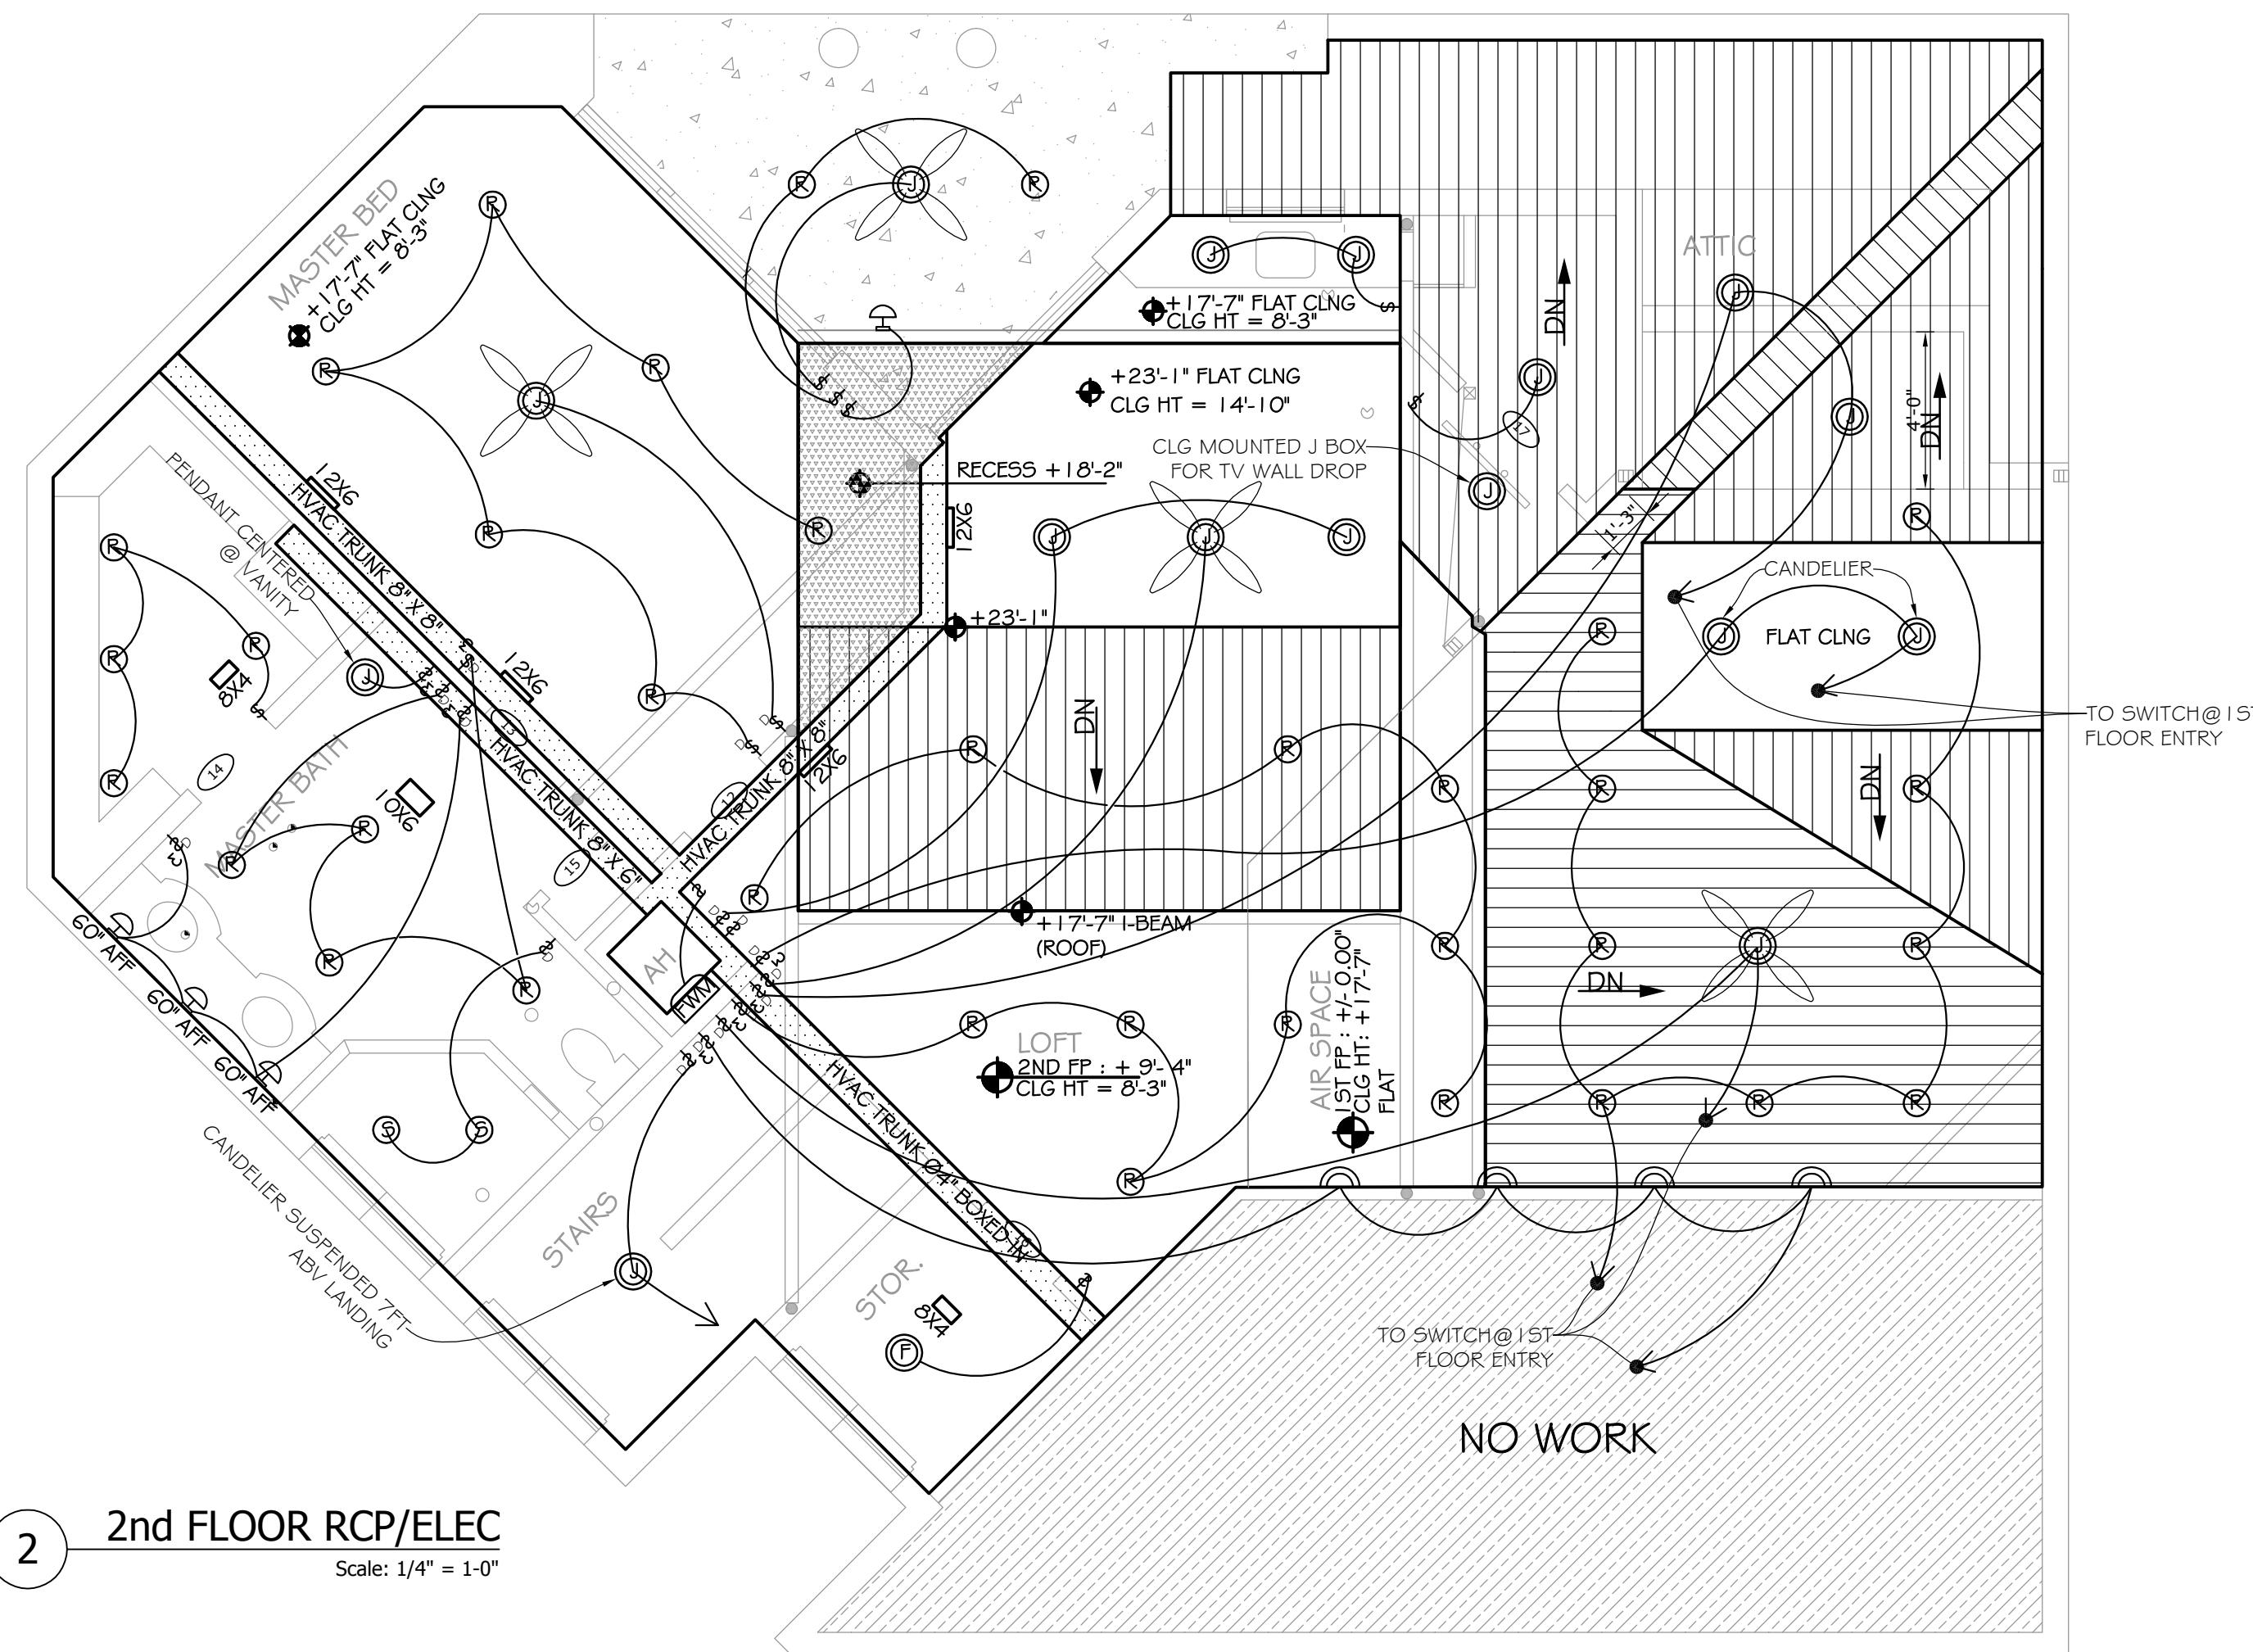

2 2nd FLOOR RCP/ELEC
Scale: 1/4" = 1'-0"

LEGEND:

- ⌒ WALL WASH UP LIGHT ON DIMMERS
- ⊙ CLNG MOUNTED J BOX ON DIMMERS
- ⊙ FLUORECENT LIGHT CLG MOUNTED SIZE AS REQUESTED
- ⊙ RECESSED CAN LIGHT ON DIMMERS
- ⊙ LV CAN LIGHT ON DIMMERS
- ⊙ SHOWER CAN ON DIMMERS
- ⌒ WALL SCONSE (@ _" AFF) ON DIMMER
- ⌚ SINGLE POLE SWITCH
- ⌚ THREE WAY SWITCH
- ⌒ FLUORECENT LIGHT WALL MOUNTED
- ⊠ HVAC VENTS 10X6

OUTDATED
07/17/2017 9:39:07 AM
FLOOR PLAN LAYOUTS SHIFTED,
CONCEPTUALLY UNCHANGED



Lic# ID 0002289
FL# 13 0001146
kelly@kellytaaffedesign.com
Tel.: 813.696.5049
Fax: 813.805.2371



INTERIOR REMODELING
THE THE PETRICK RESIDENCE
939 SEDDON COVE WAY, TAMPA FL 33602

CONTRACTOR:

TO BE DETERMINED

PUBLISHED: 6/12/2017 7:49:57 PM
REVISIONS: DATE

△		
△		
△		

SHEET NAME:
RCP/ELECTR.

DRAWN: SB CHECKED: KTD
SHEET NO:
A

RCP5.dwg